
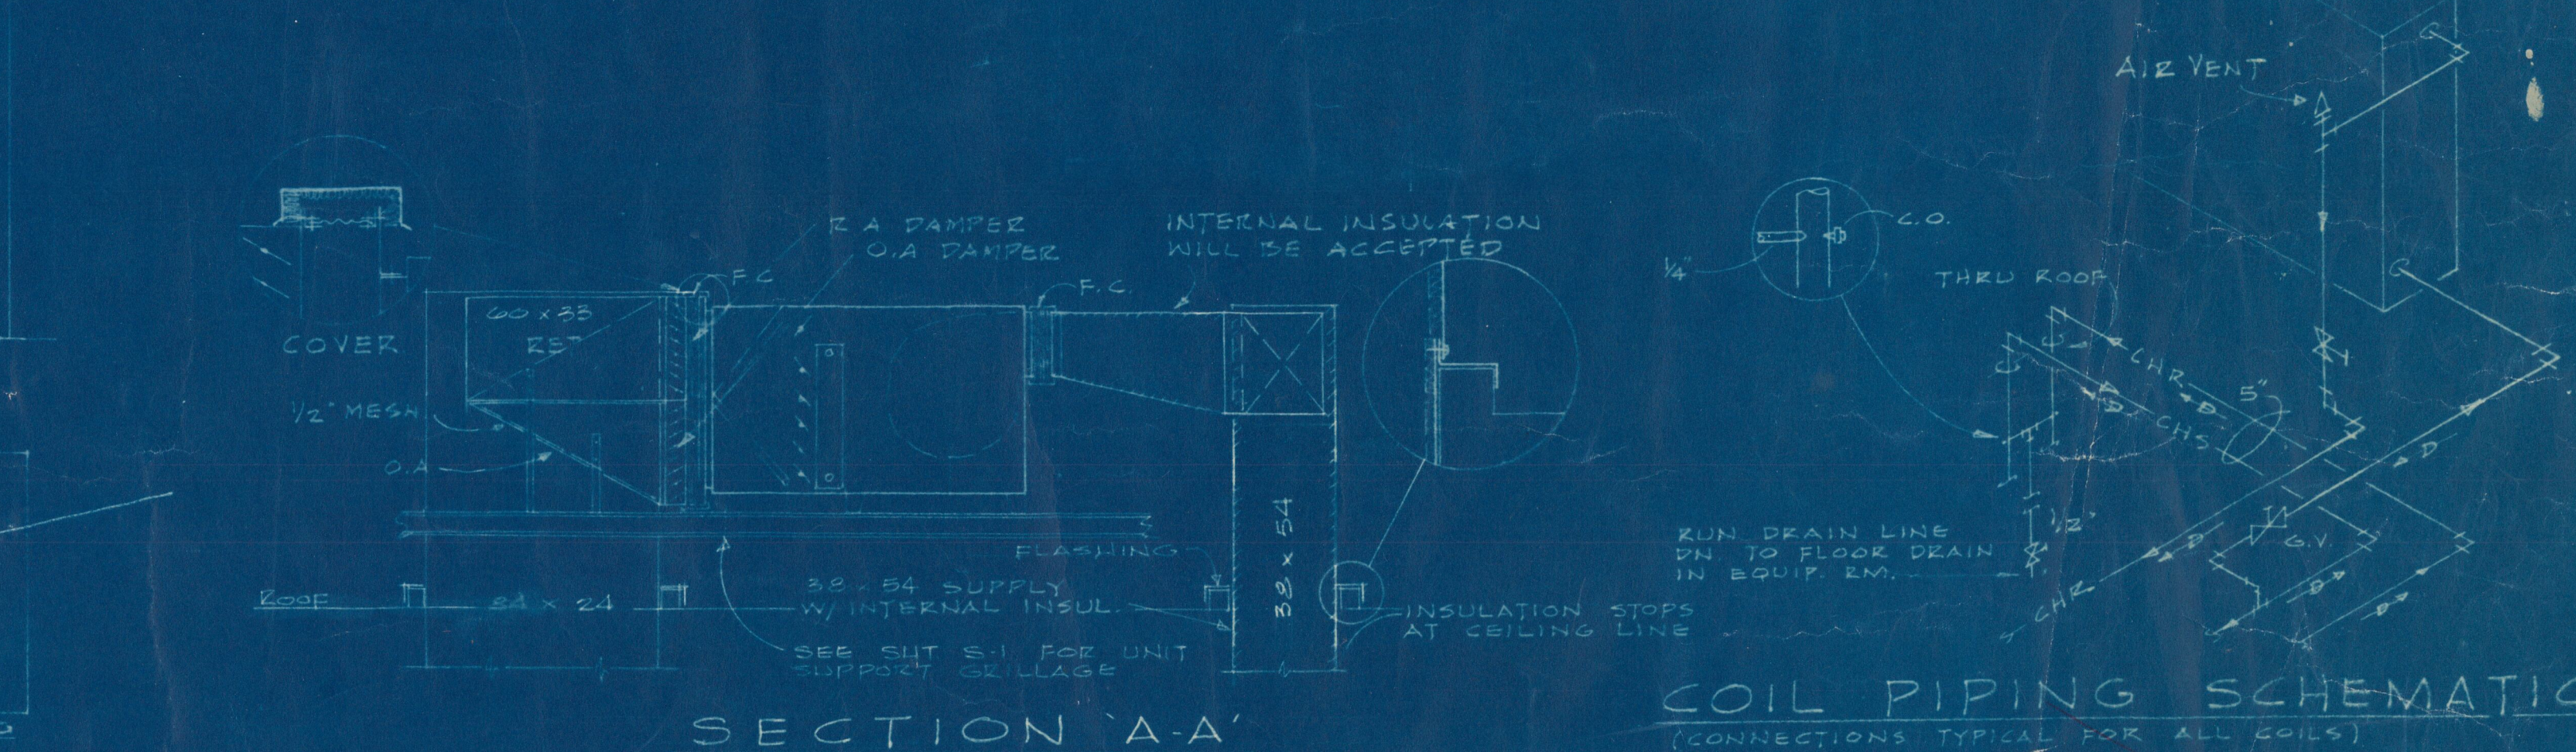
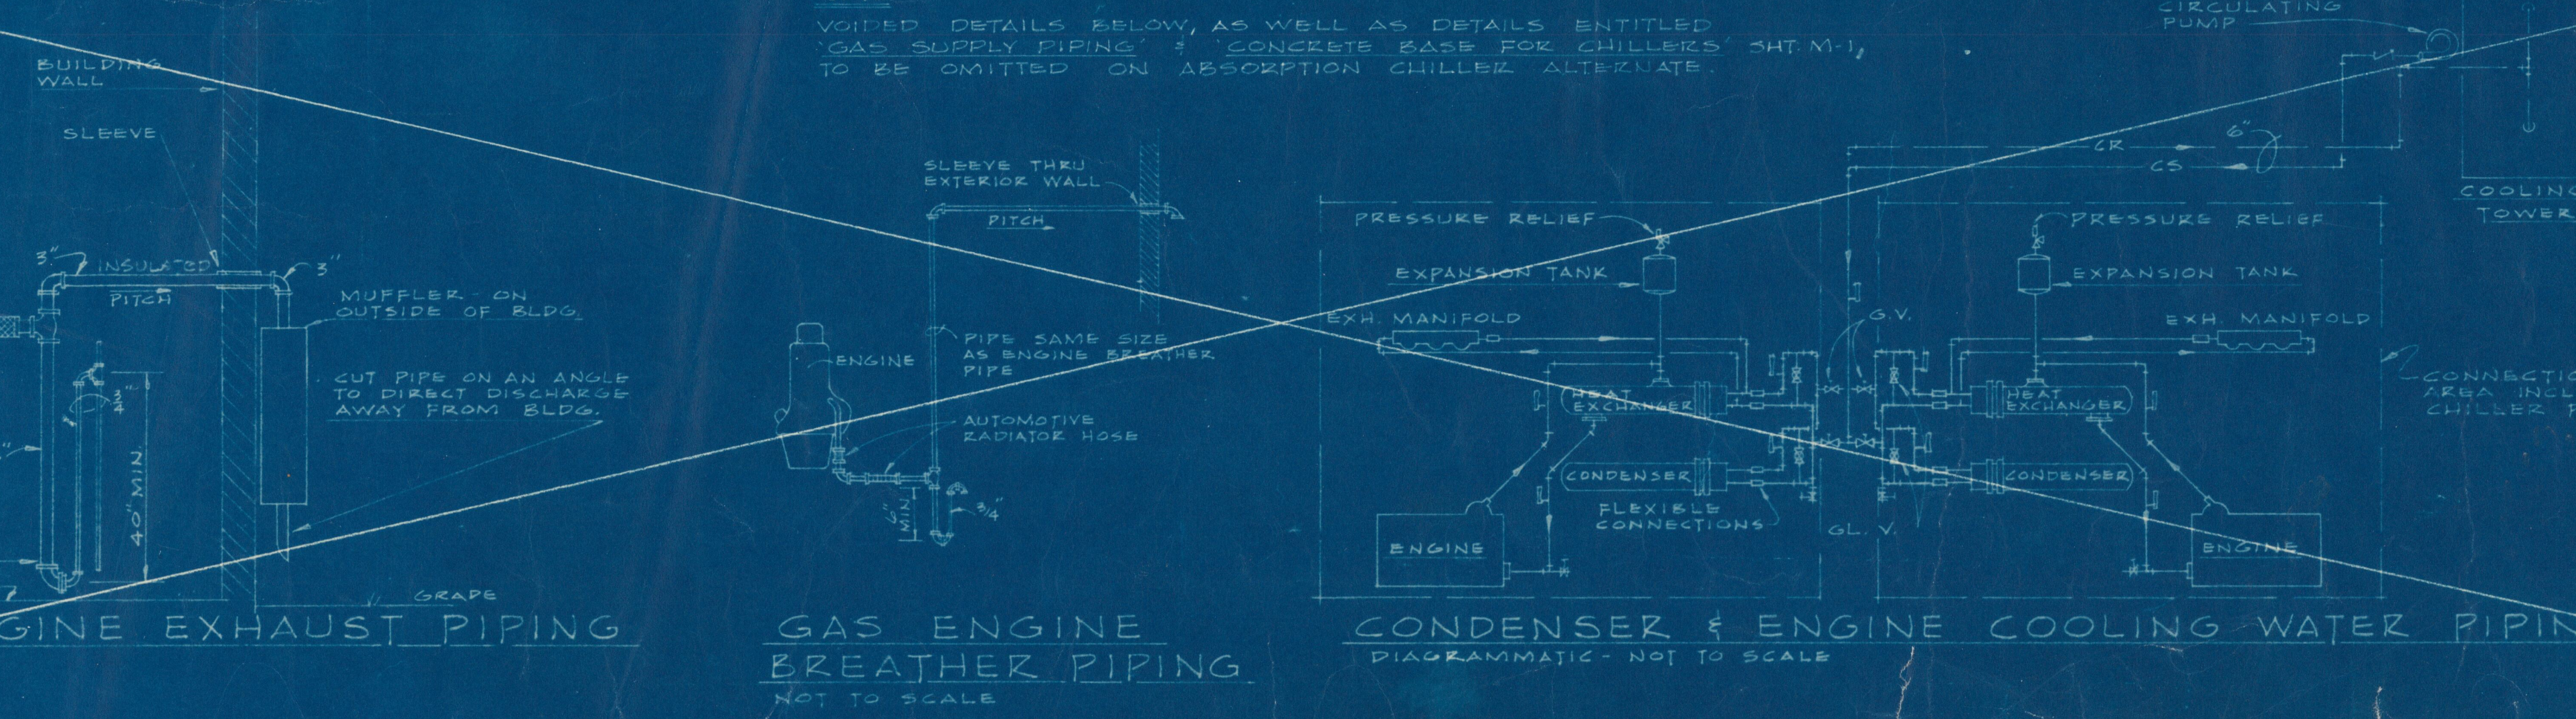
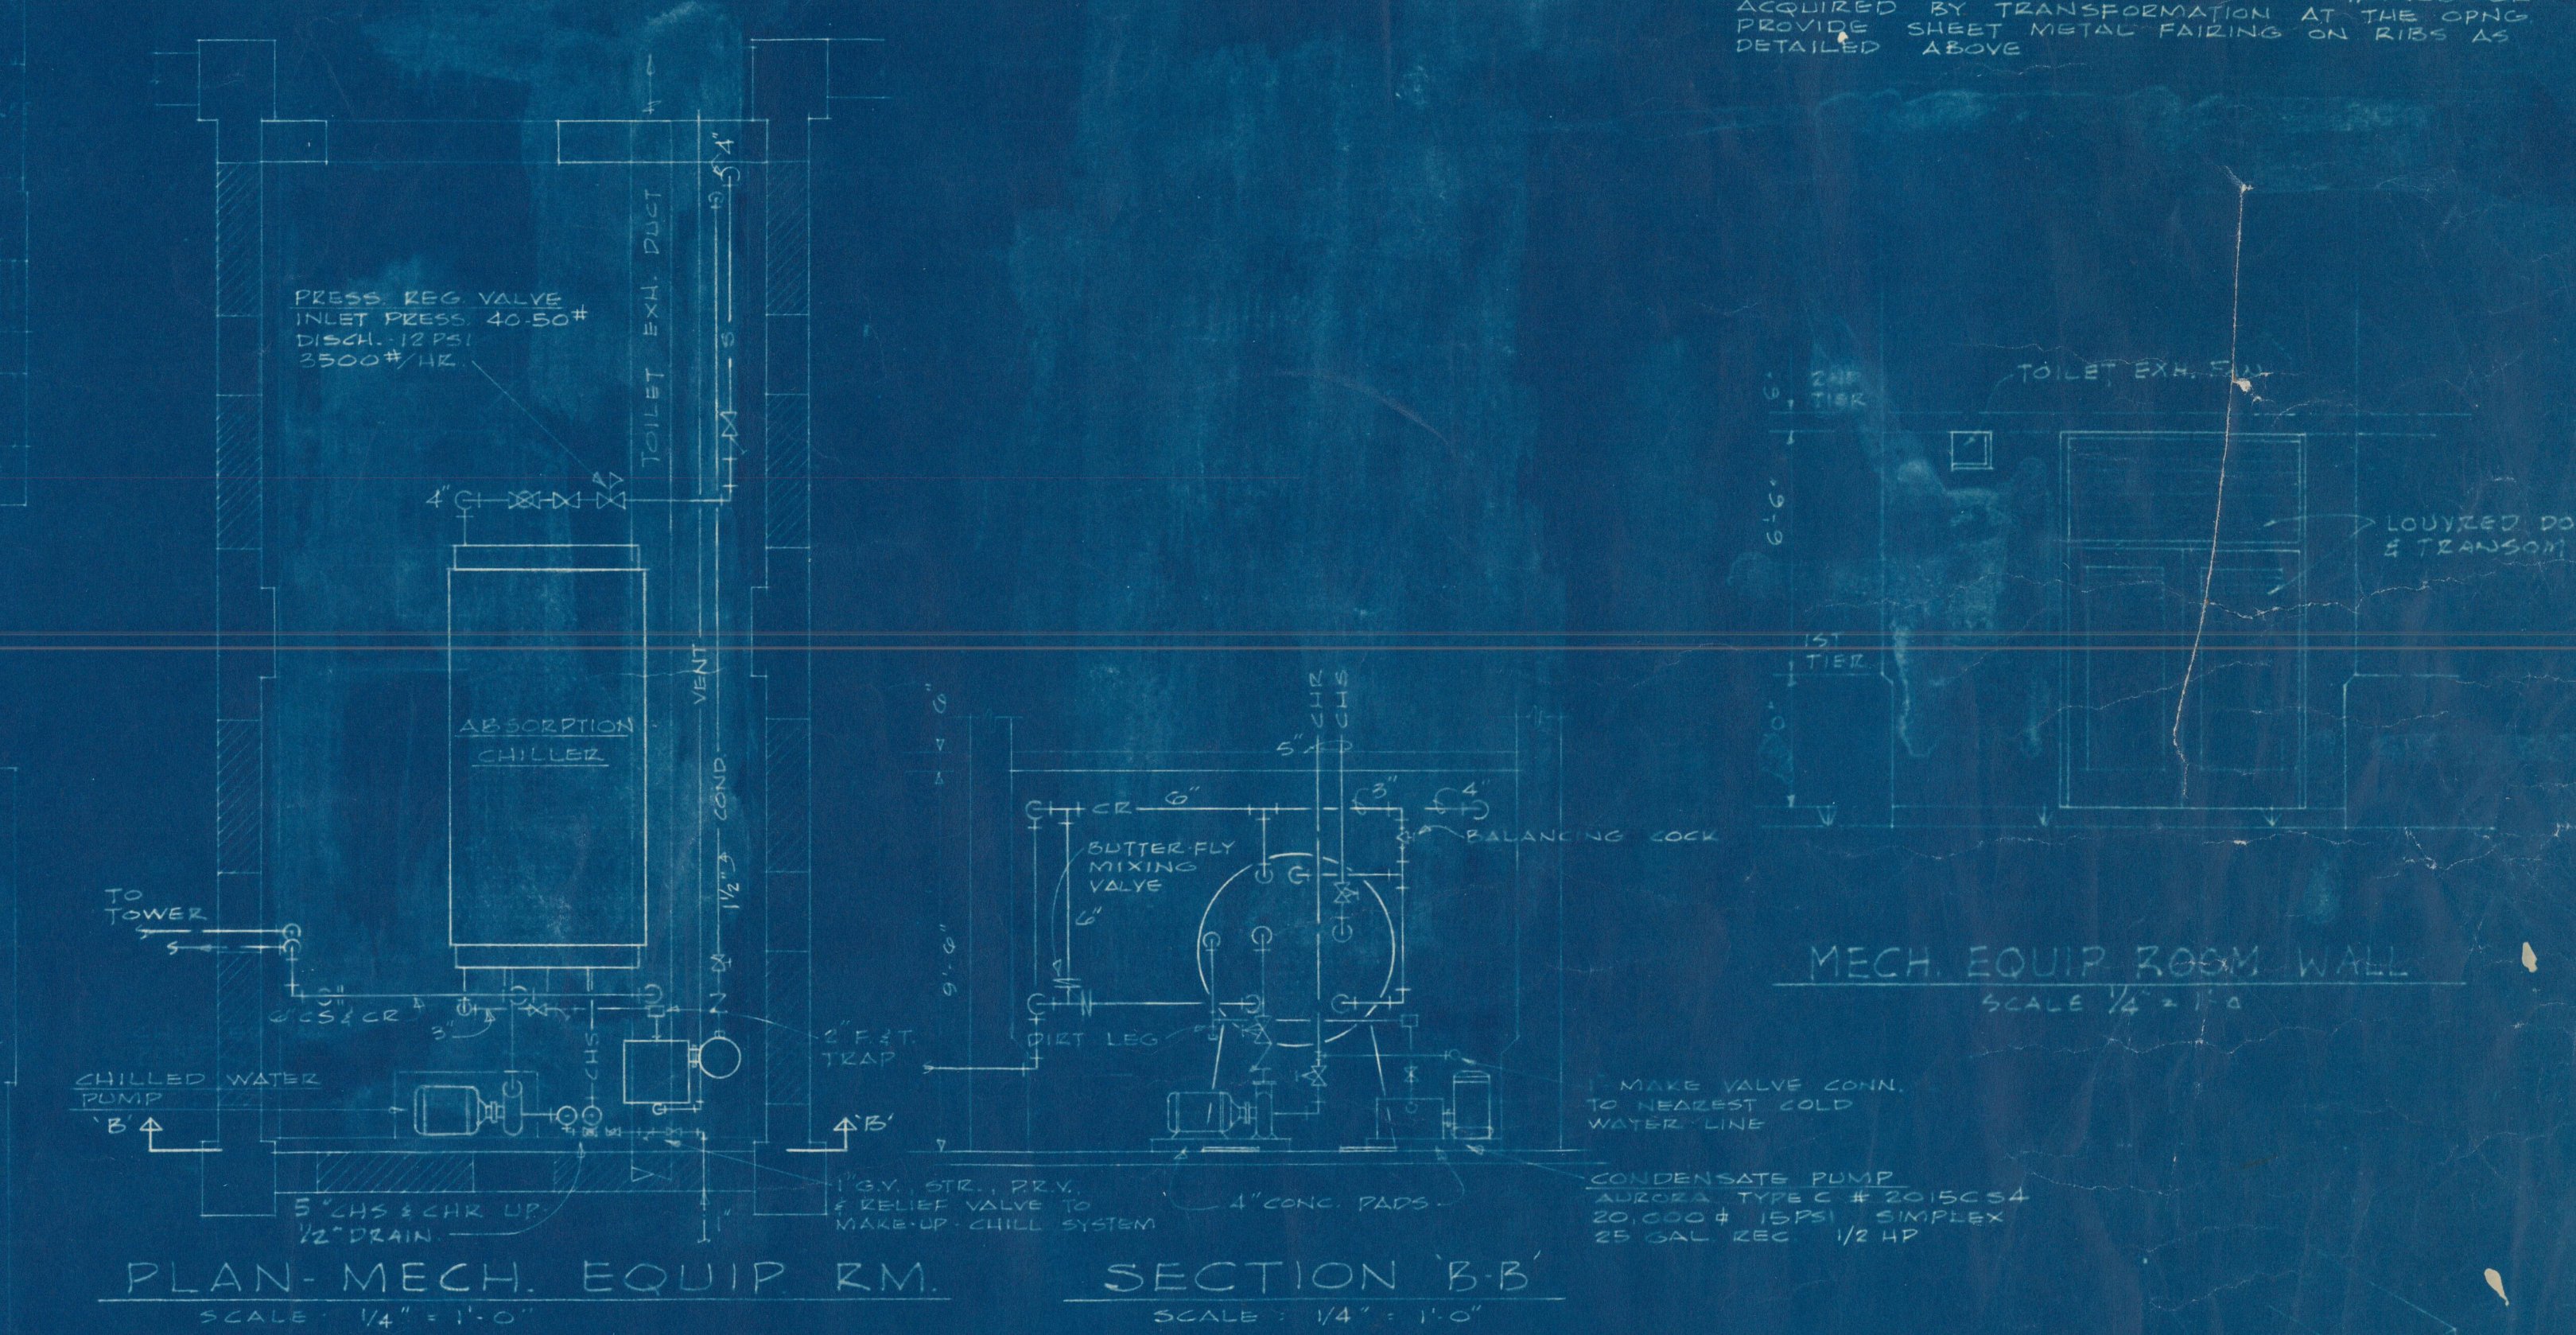
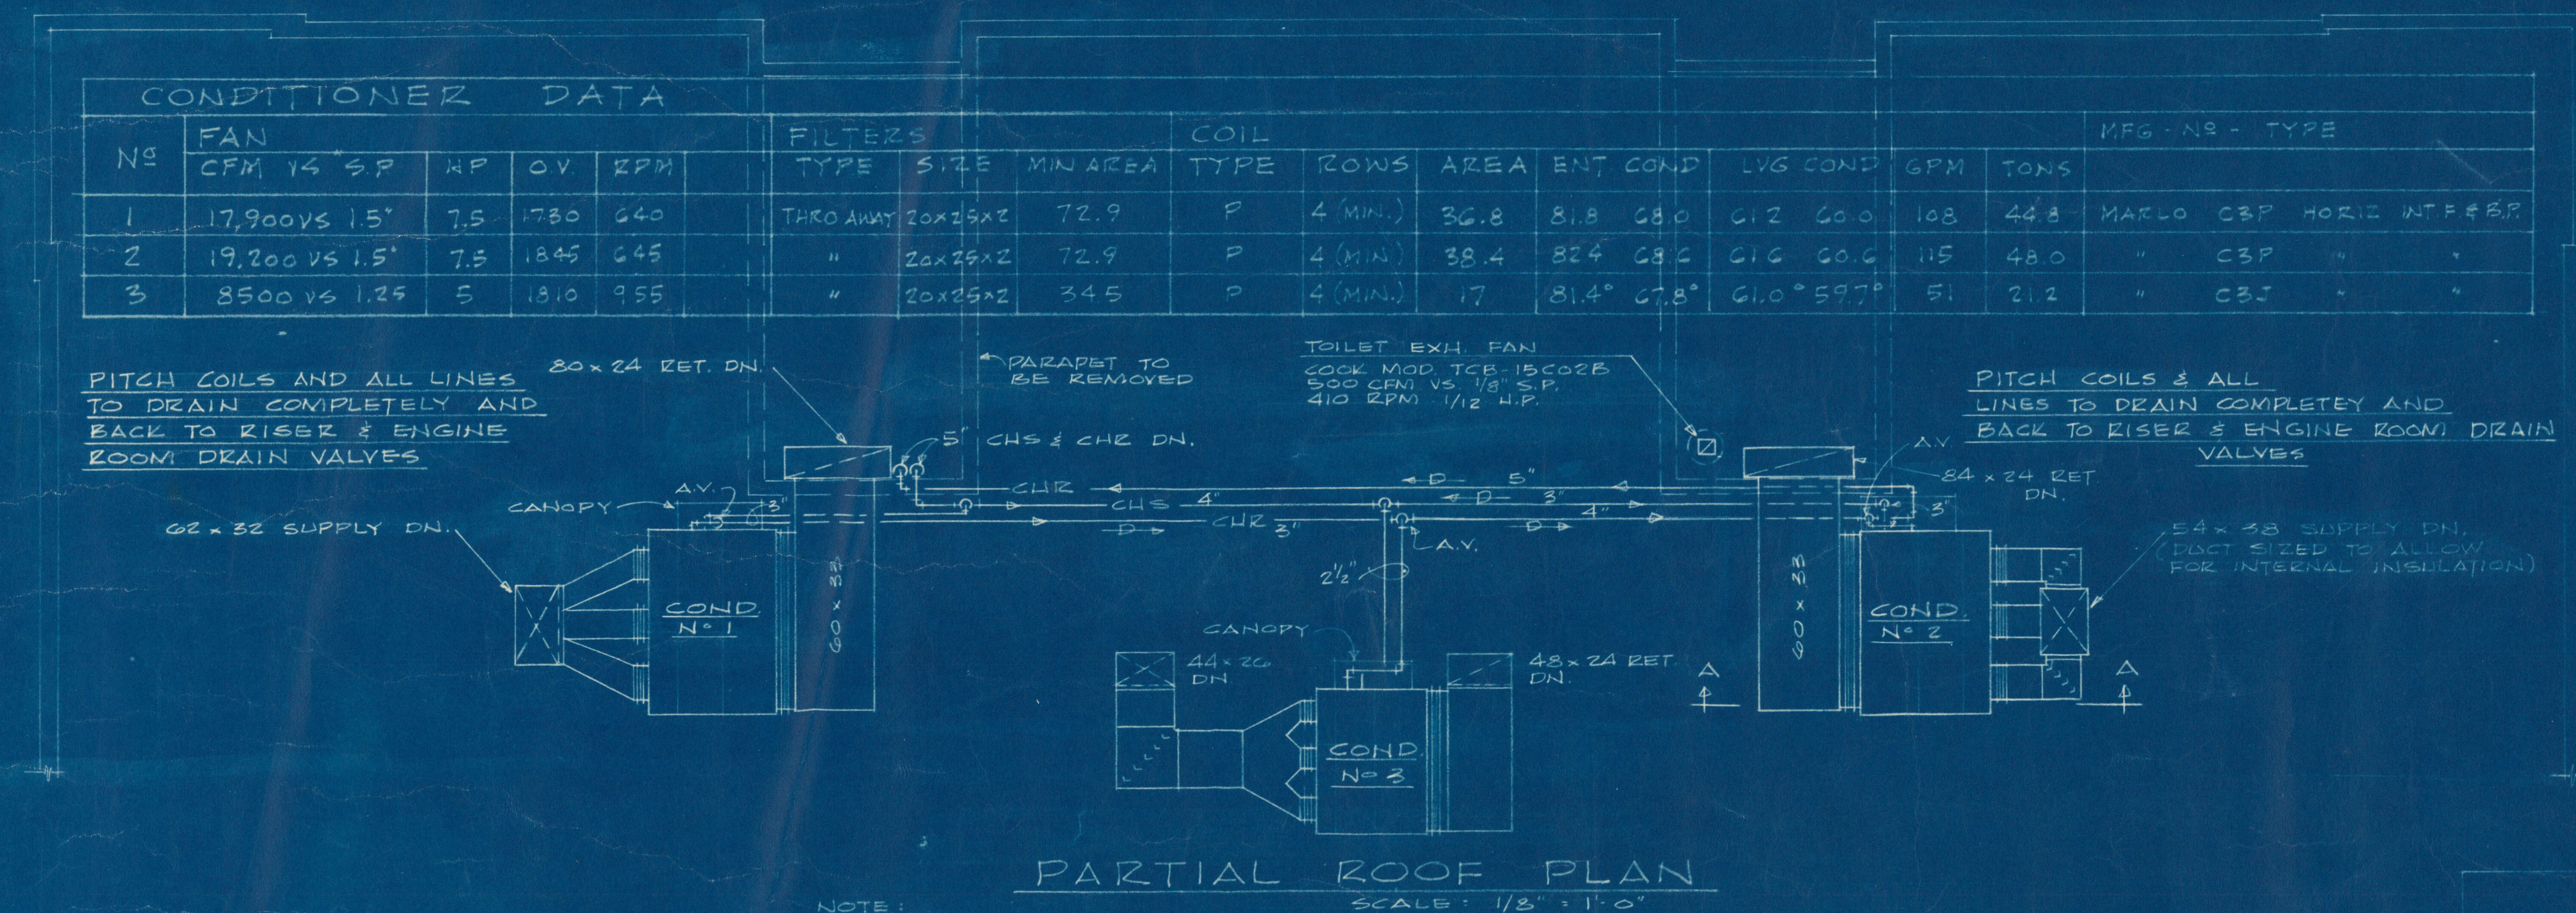
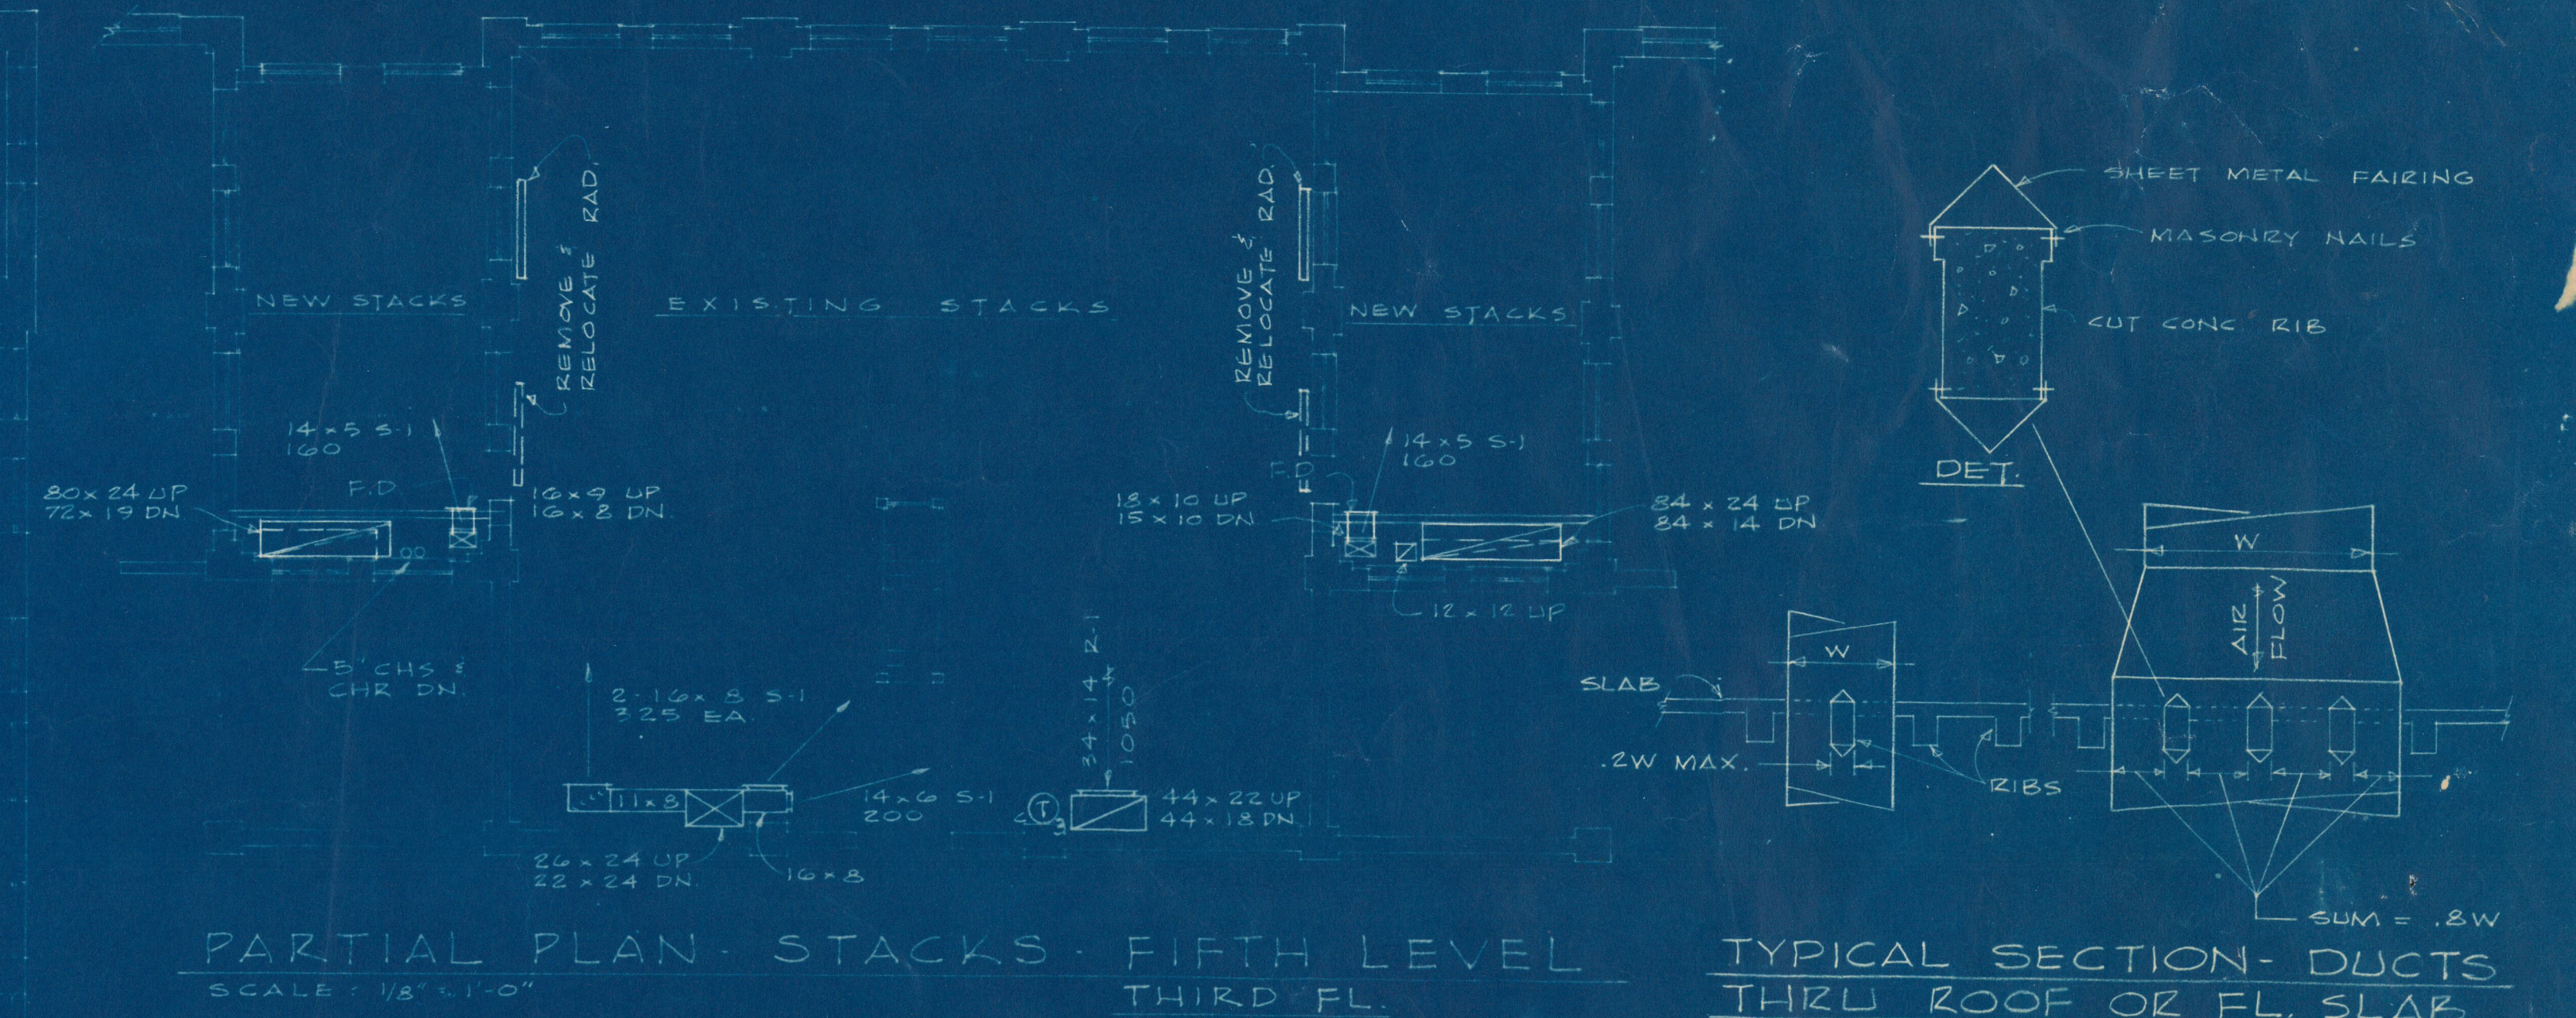


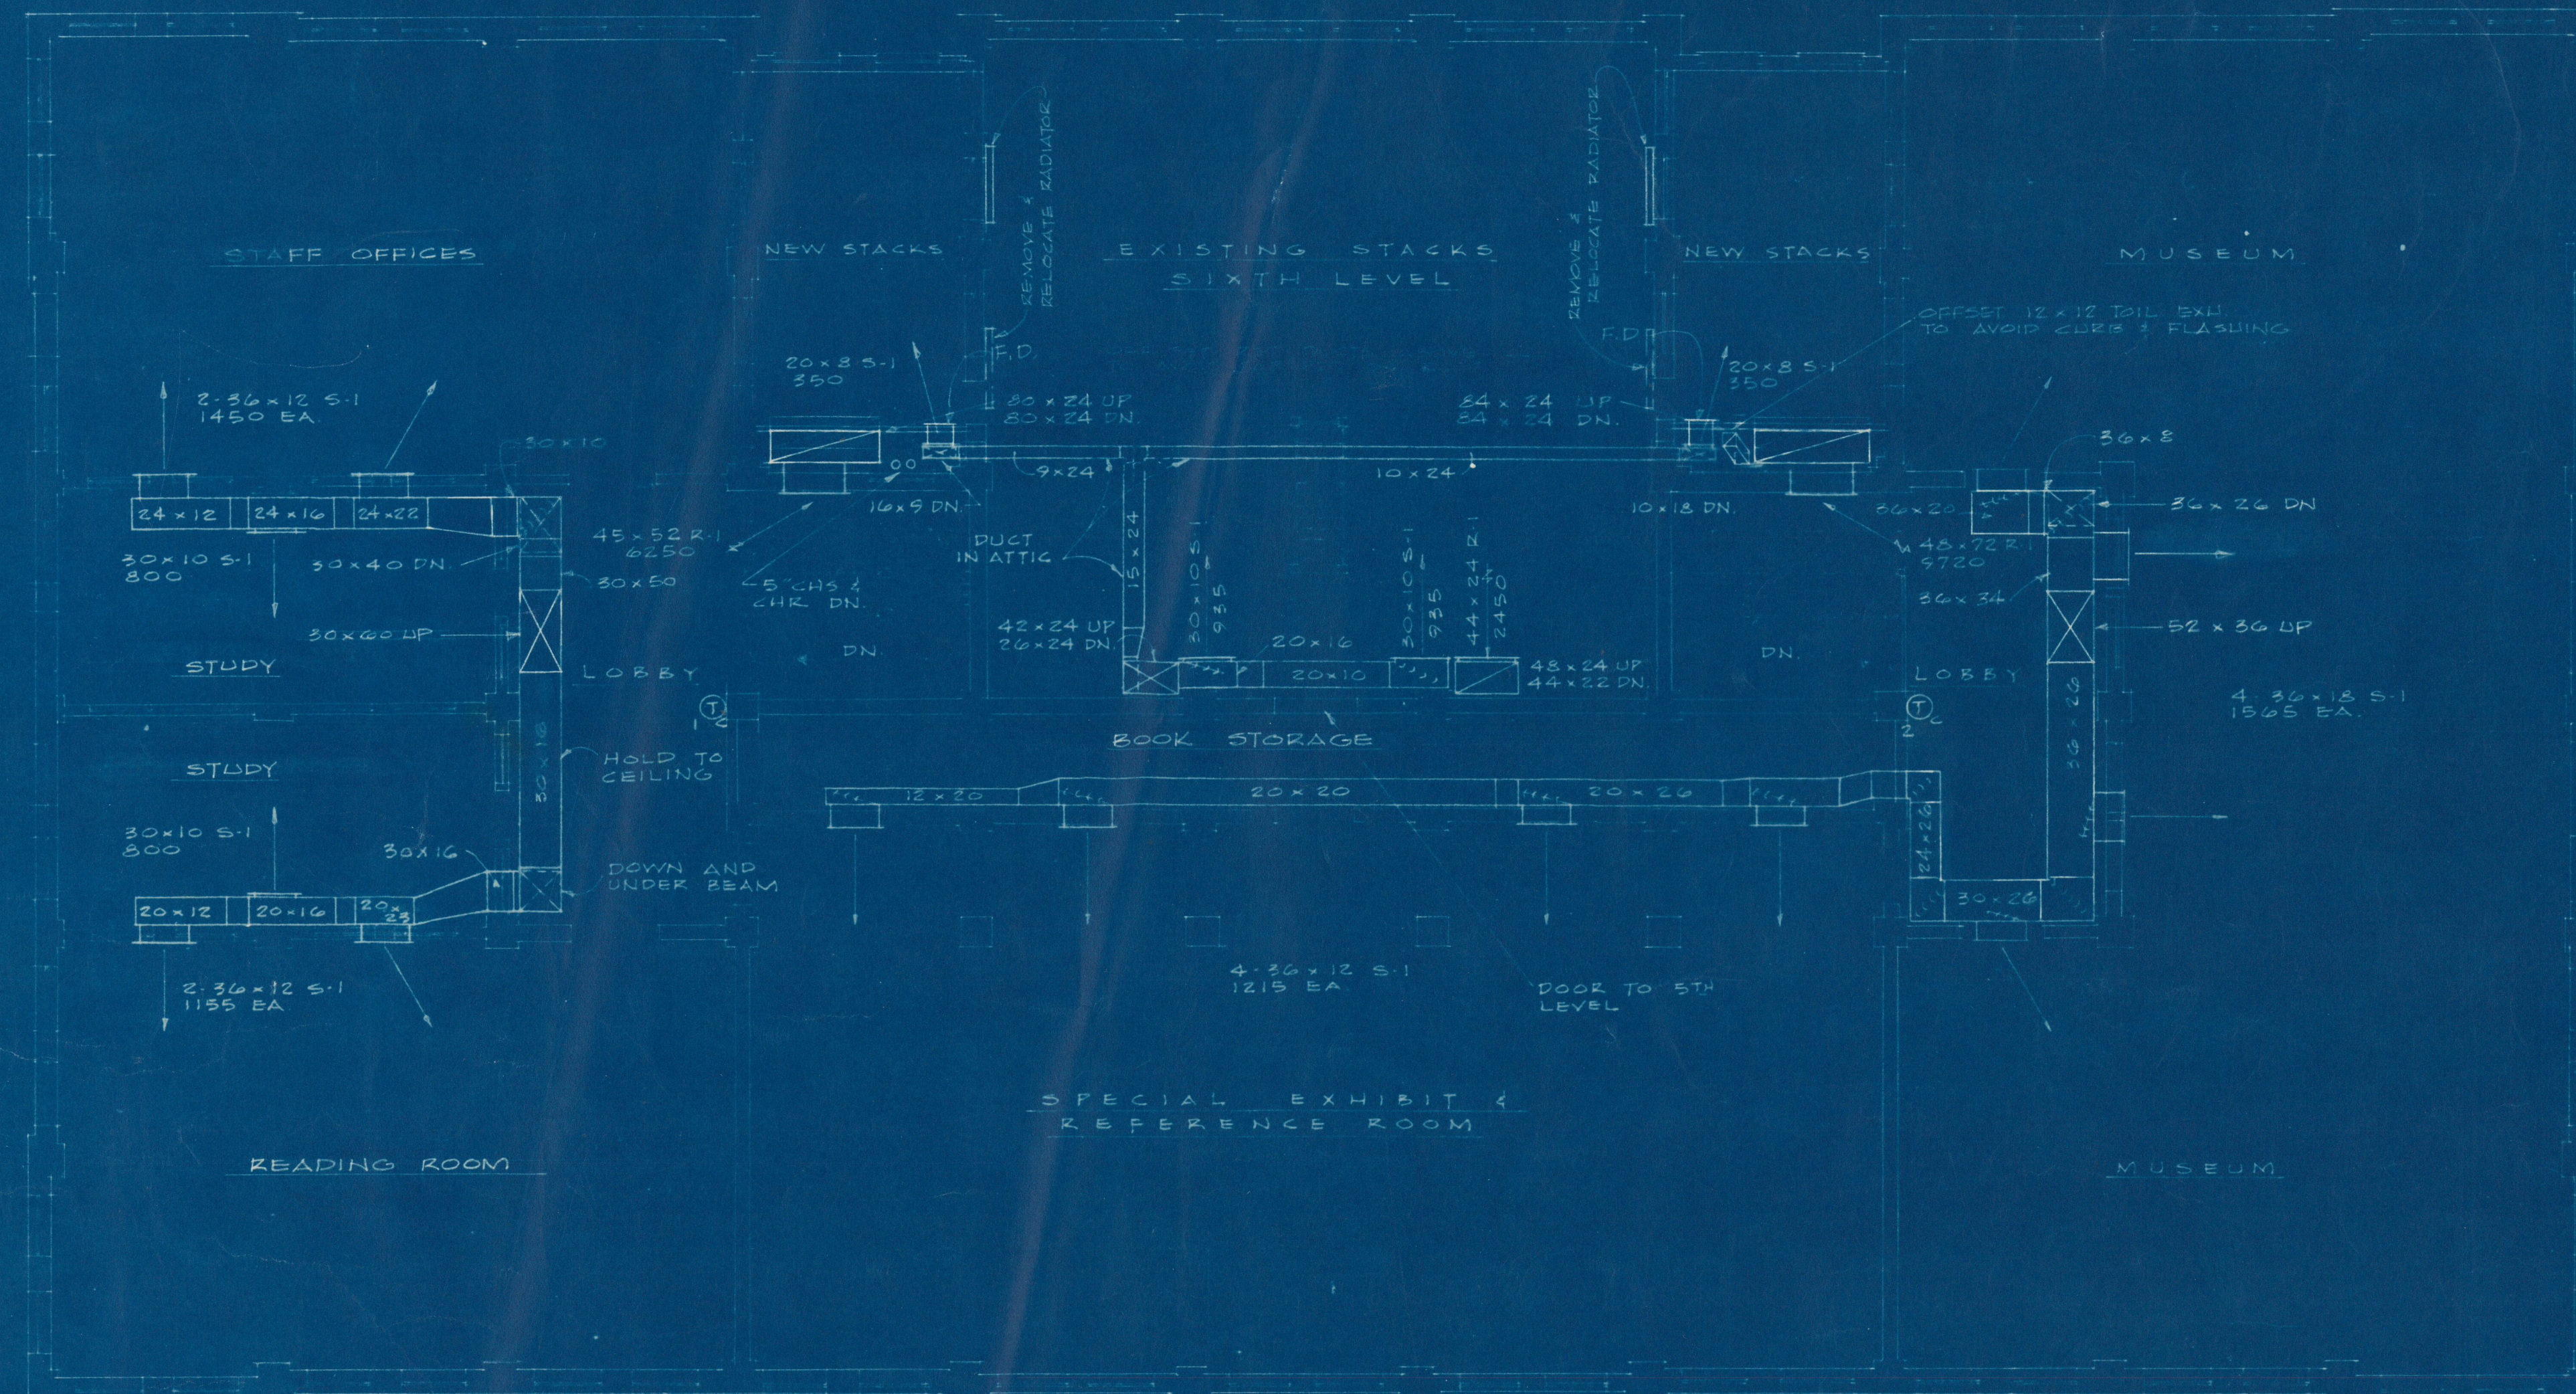

ADDITION & RENOVATION LIBRARY BUILDING		DRAWN	
PROJECT NO. ALA. 4-0361 TUSKEGEE INSTITUTE TUSKEGEE INSTITUTE, ALABAMA		TRACED	
HEATING, VENTILATING AND AIR CONDITIONING		APPROVED	
THIRD FLOOR & ROOF PLANS		DATE 12/10/65	
MILLER AND ALLAIN, ARCHITECTS ATLANTA, GEORGIA		DRAWING NO.	
REVISIONS			