




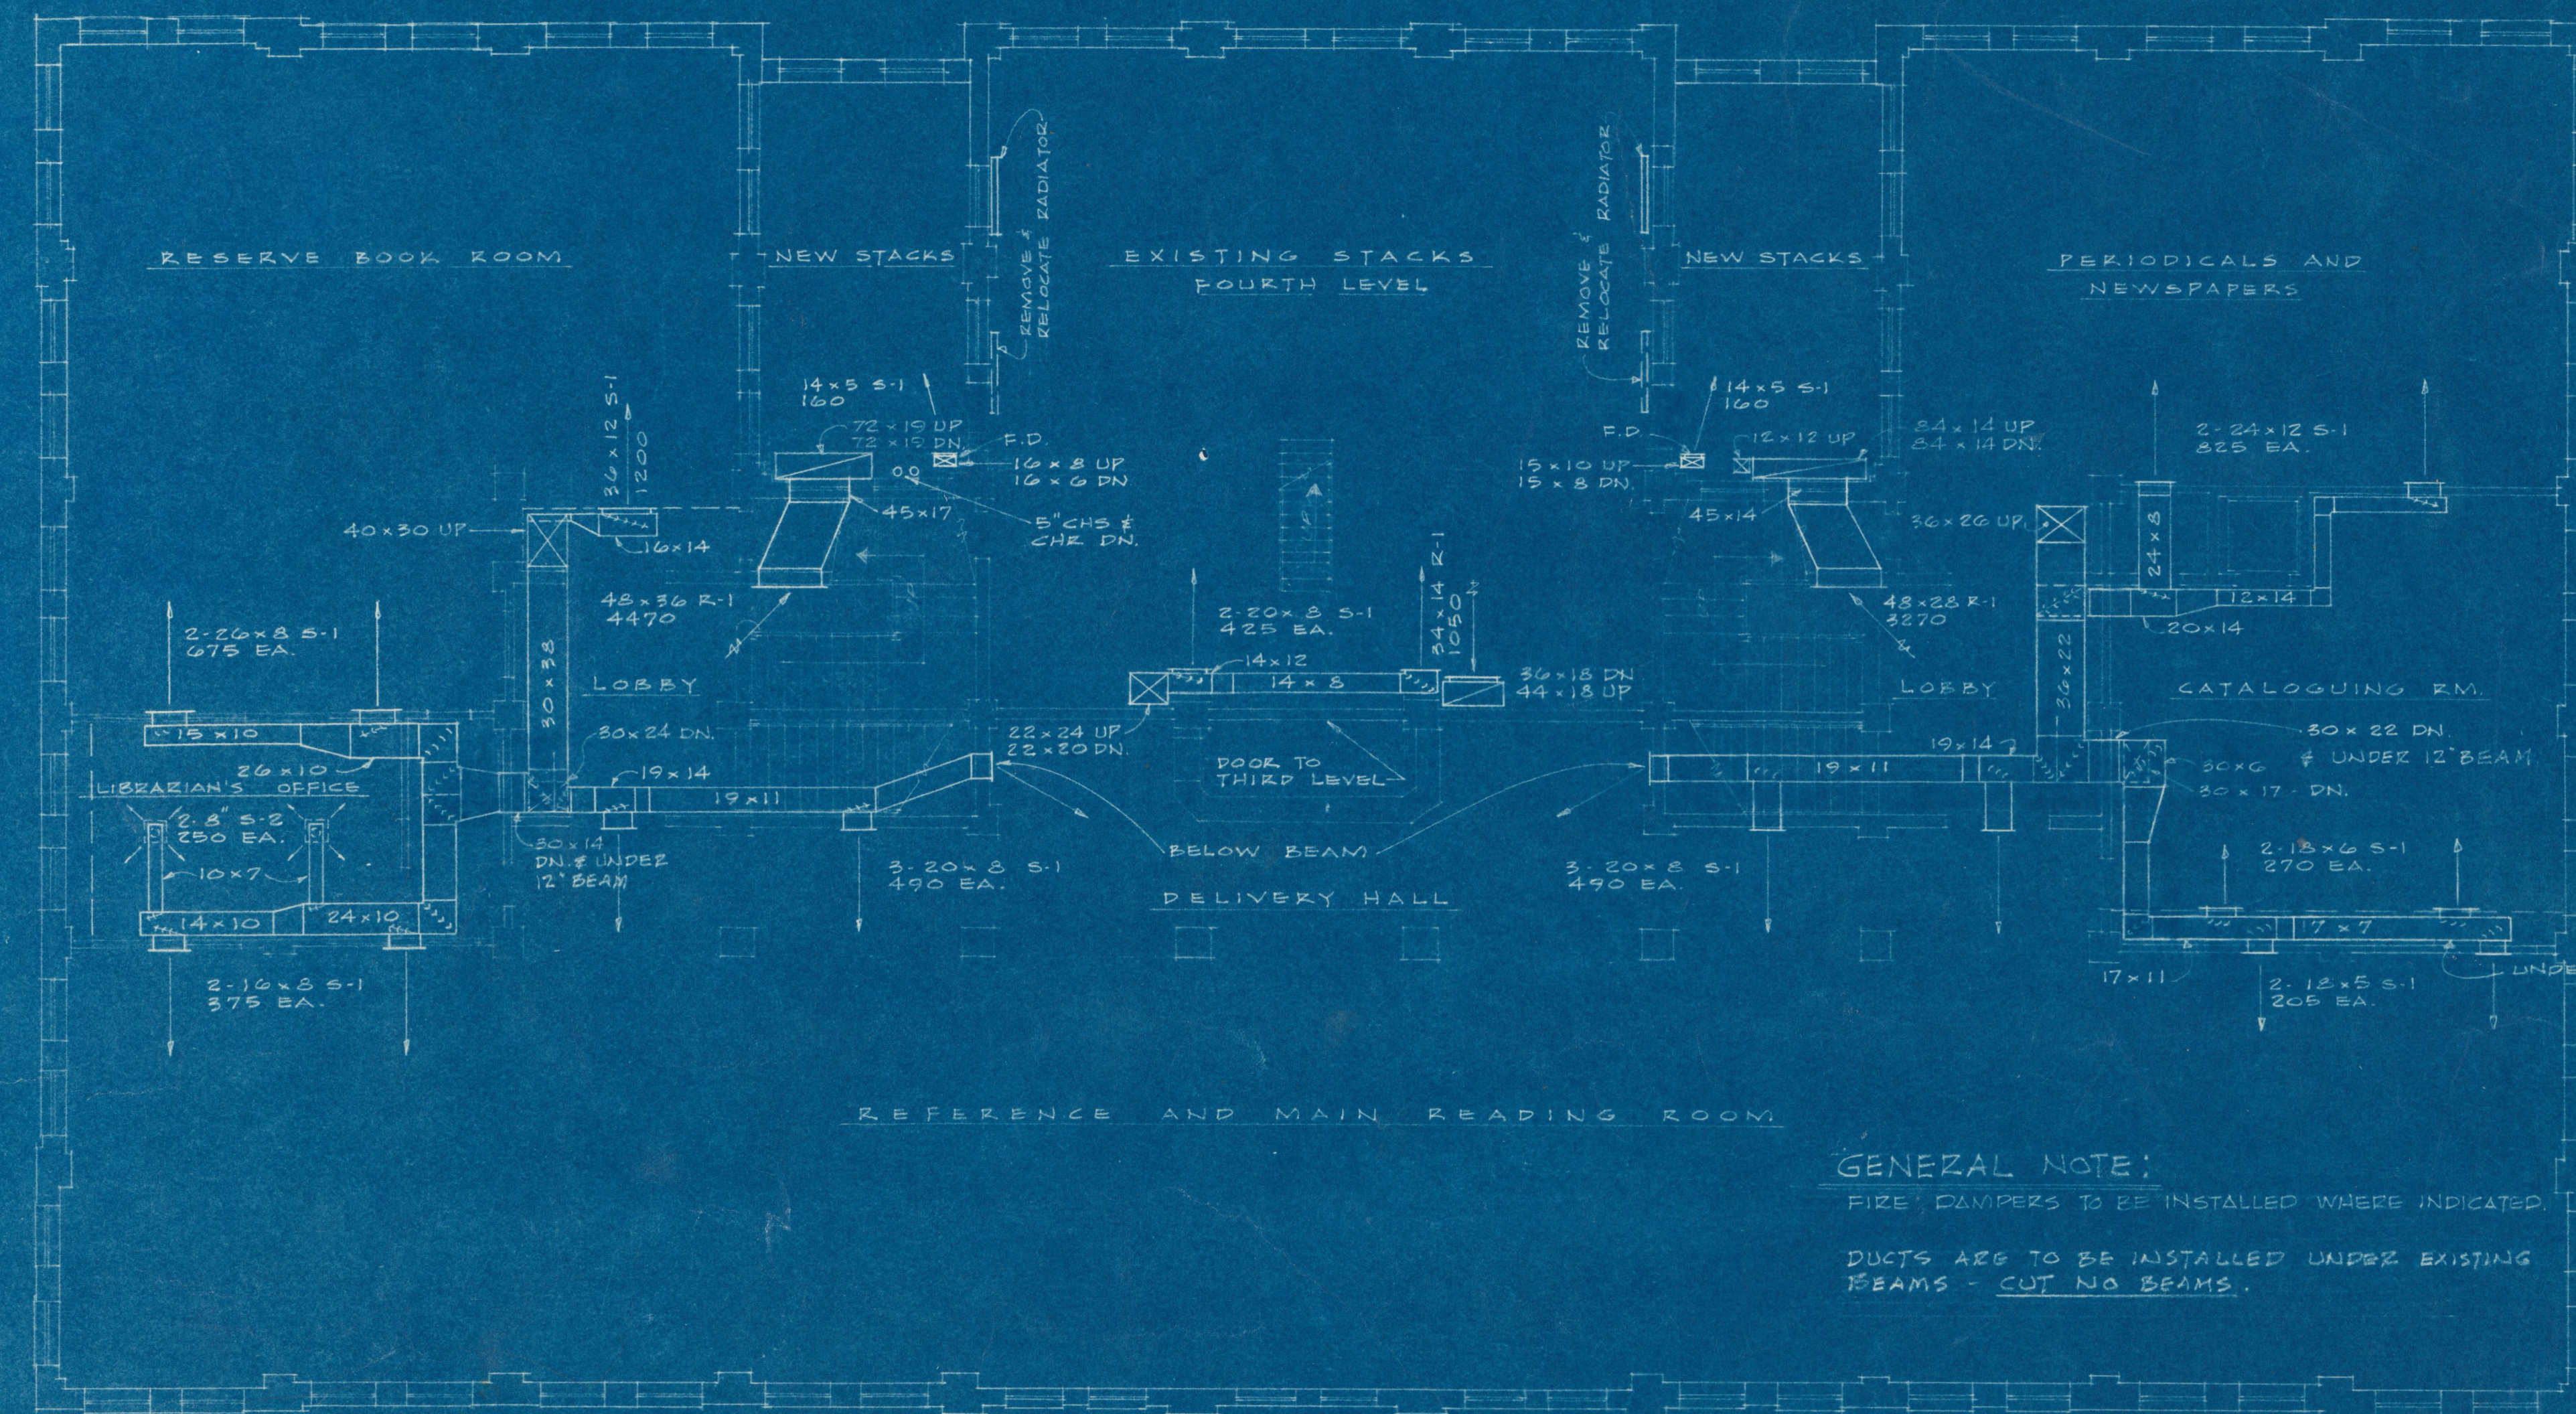

SECOND FLOOR
SCALE: 1/8" = 1'-0"

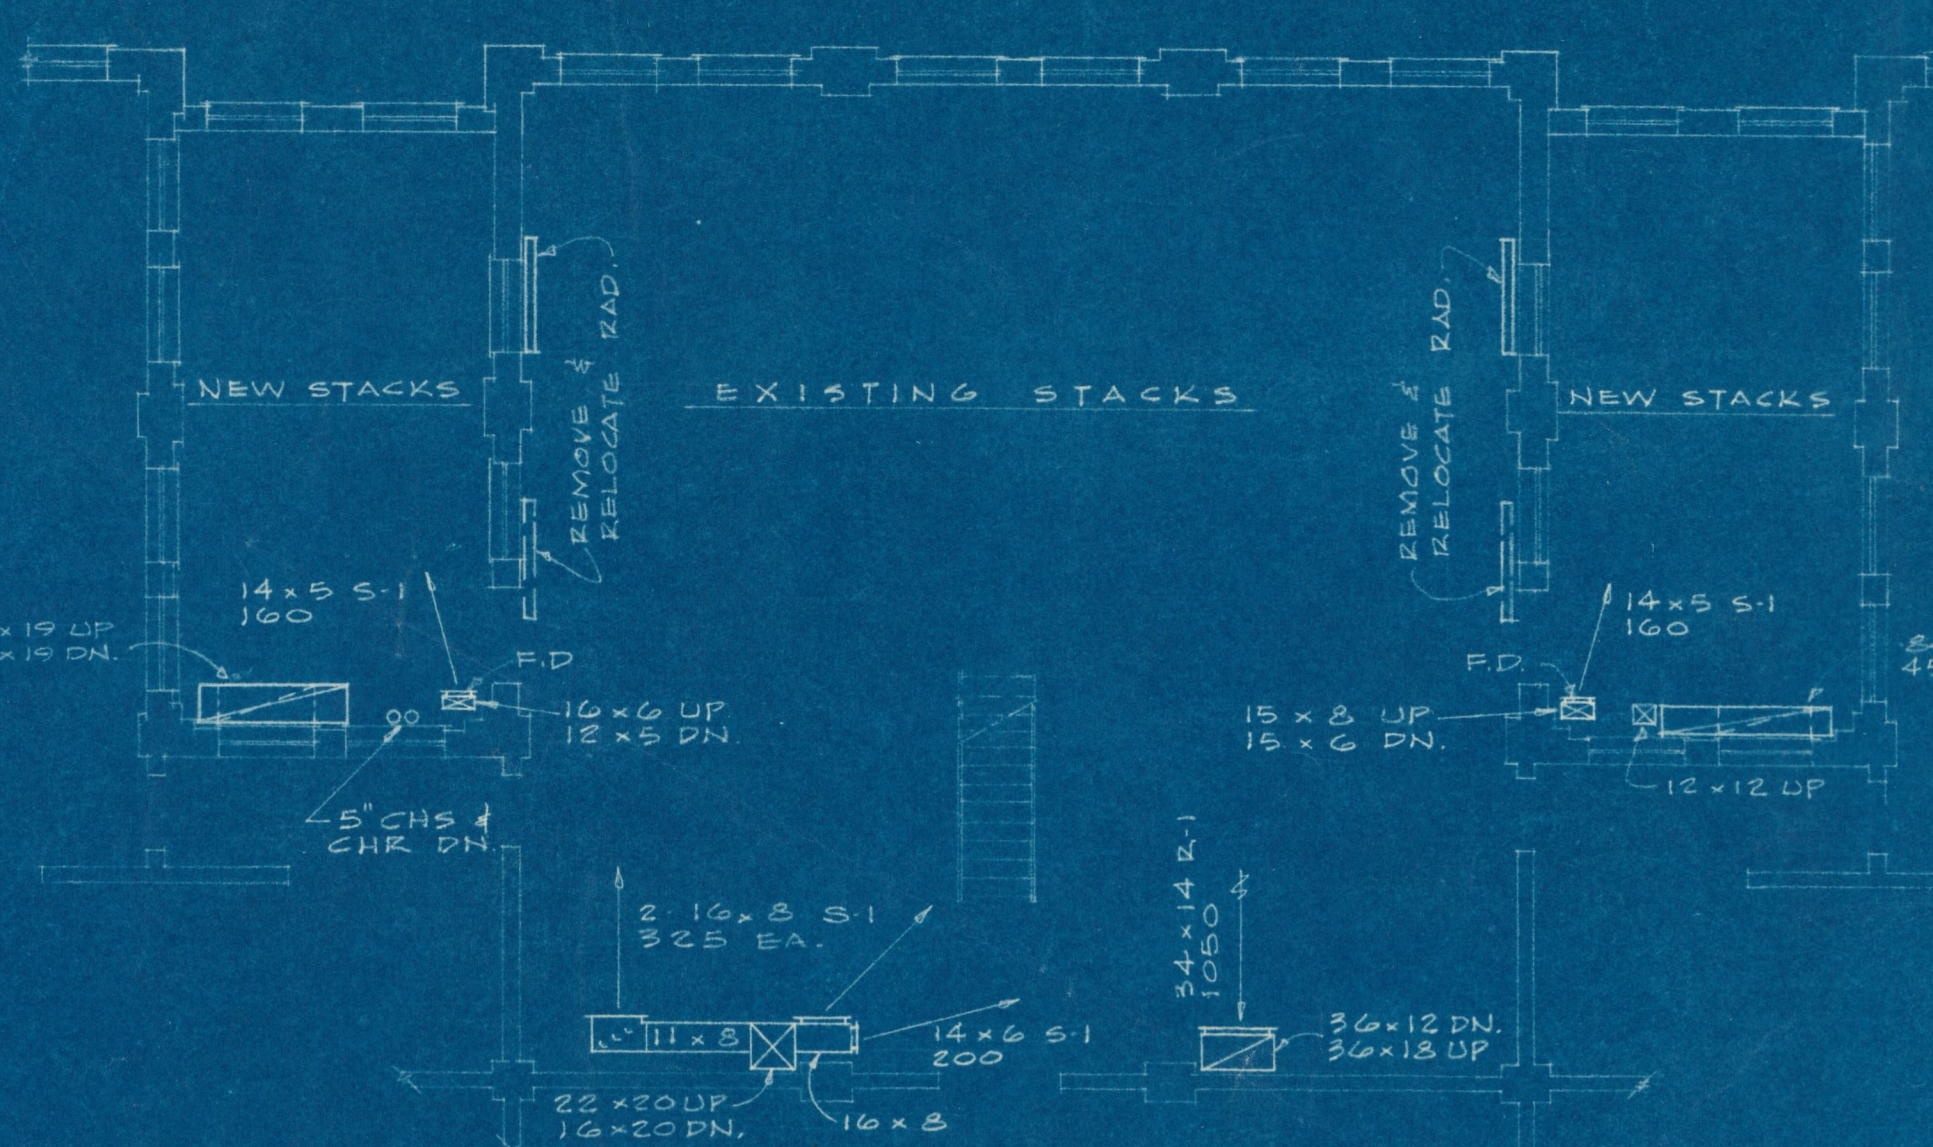


PARTIAL PLAN - STACKS - THIRD LEVEL
SCALE: 1/8" = 1'-0"

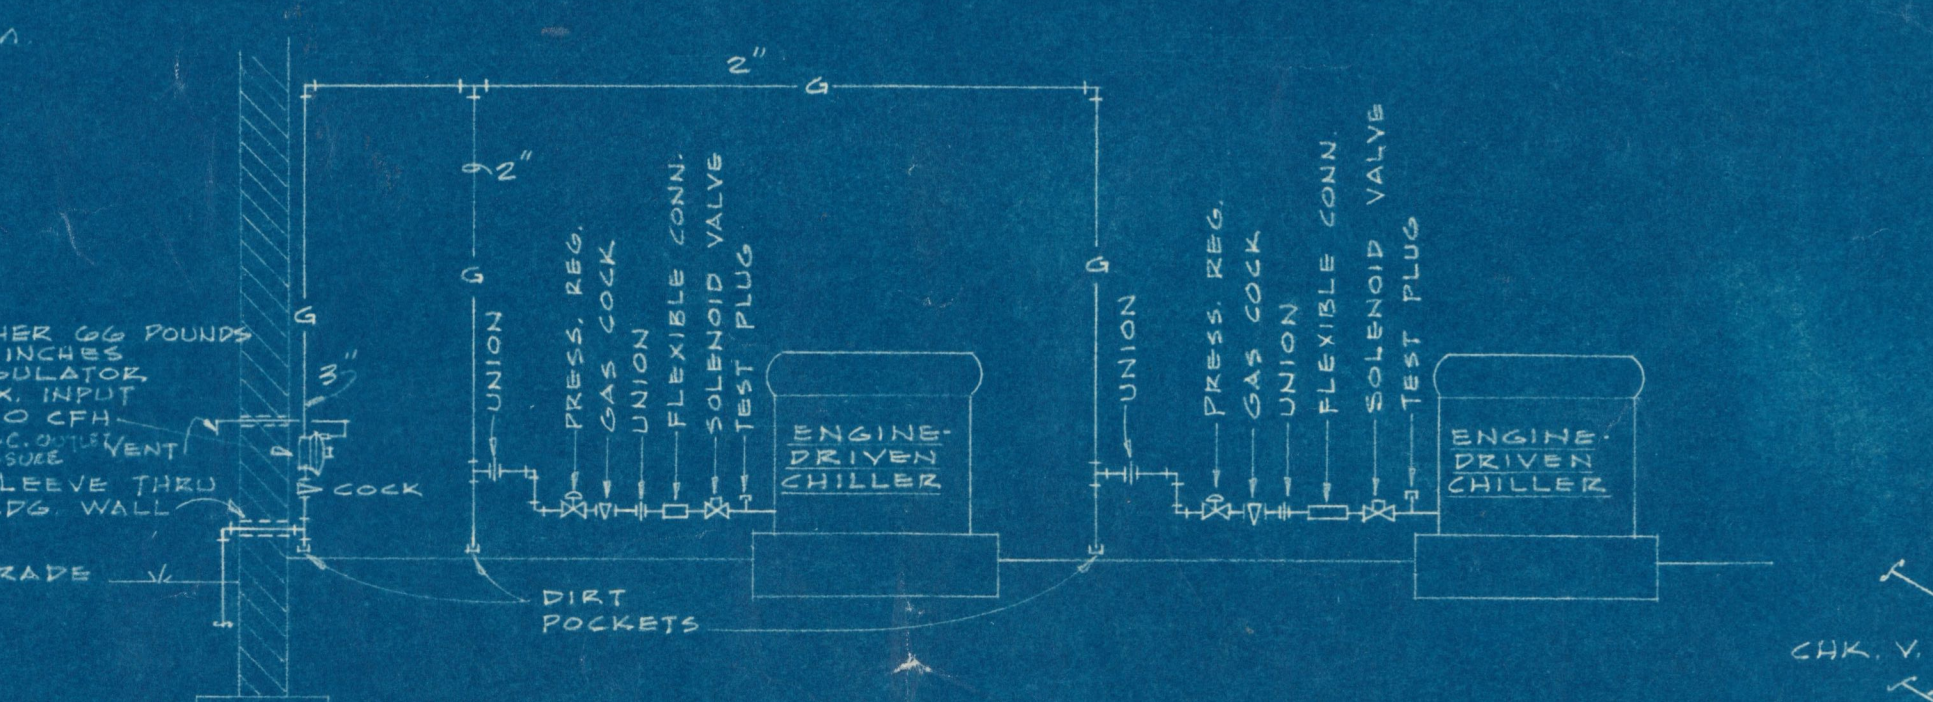


GAS SUPPLY PIPING
DIAGRAMMATIC - NOT TO SCALE

LEGEND


SYMBOL	ABBREV.	DESCRIPTION
CHS	CHS	CHILLED WATER SUPPLY
CHR	CHR	CHILLED WATER RETURN
CS	CS	CONDENSER SUPPLY
CR	CR	CONDENSER RETURN
G	G	GAS
EXH	EXH	EXHAUST
D	D	DRAIN
GV	GV	GATE VALVE
GLV	GLV	GLOBE VALVE
CHK.V	CHK.V	CHECK VALVE
CV	CV	CONTROL VALVE
STR.	STR.	STRAINER
		THERMOMETER
		PRESSURE GAGE
		DIRECTION OF FLOW
		DIRECTION OF DRAINAGE
AV	AV	AUTOMATIC AIR VENT
		THERMOSTAT COOLING
		FIRE DAMPER

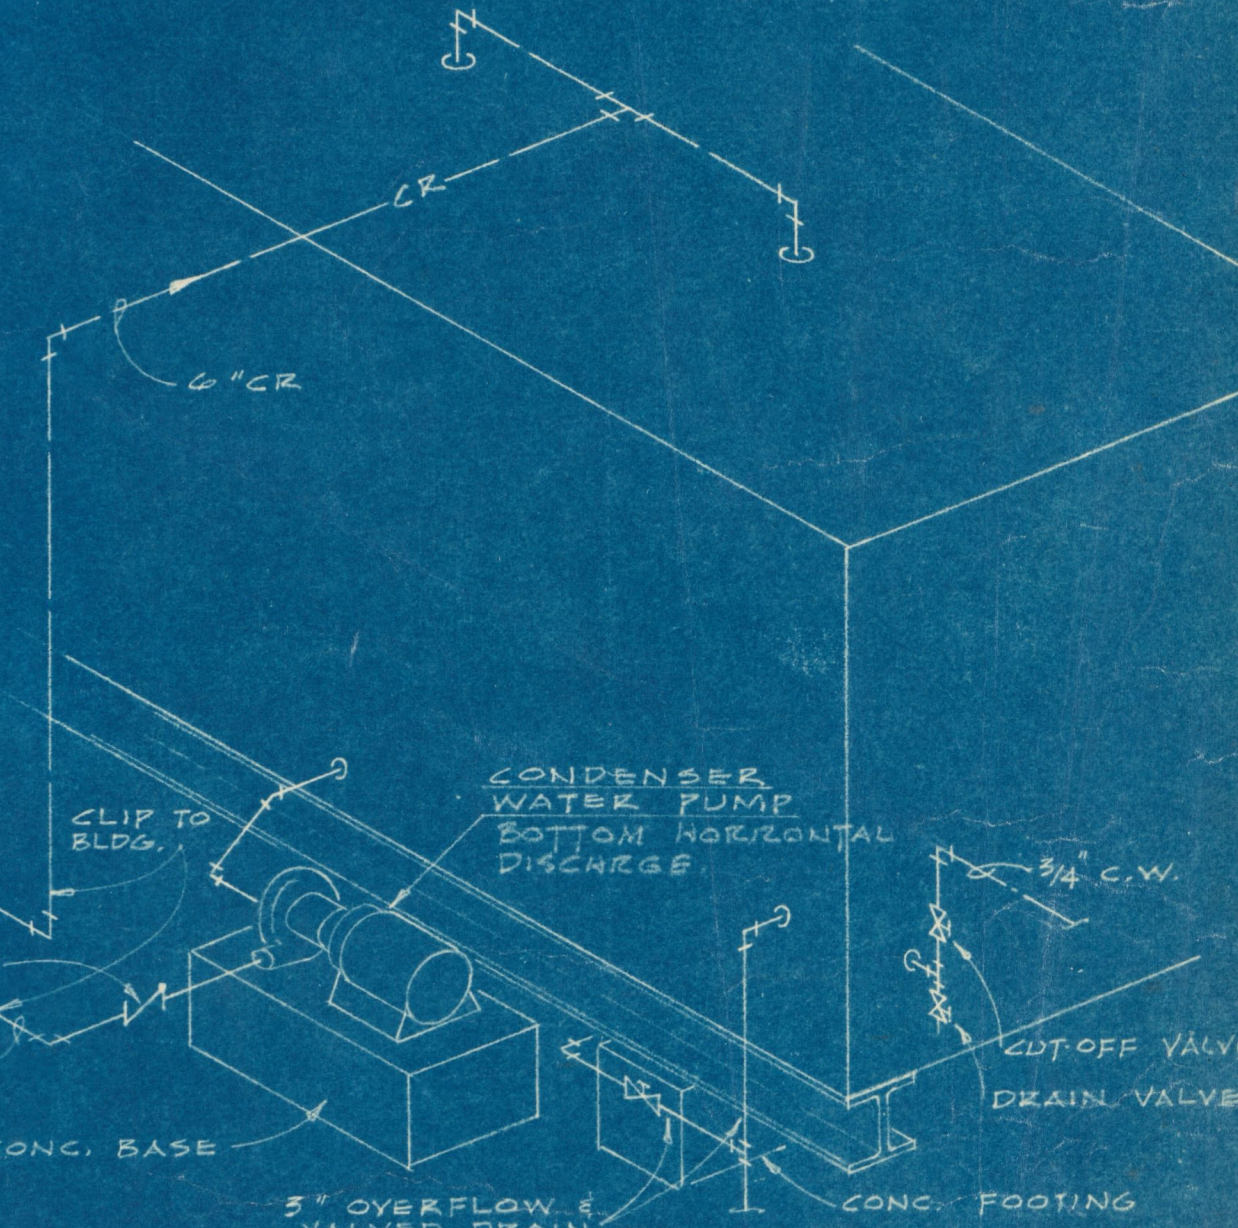

TOWER & PUMP DETAIL
NO SCALE

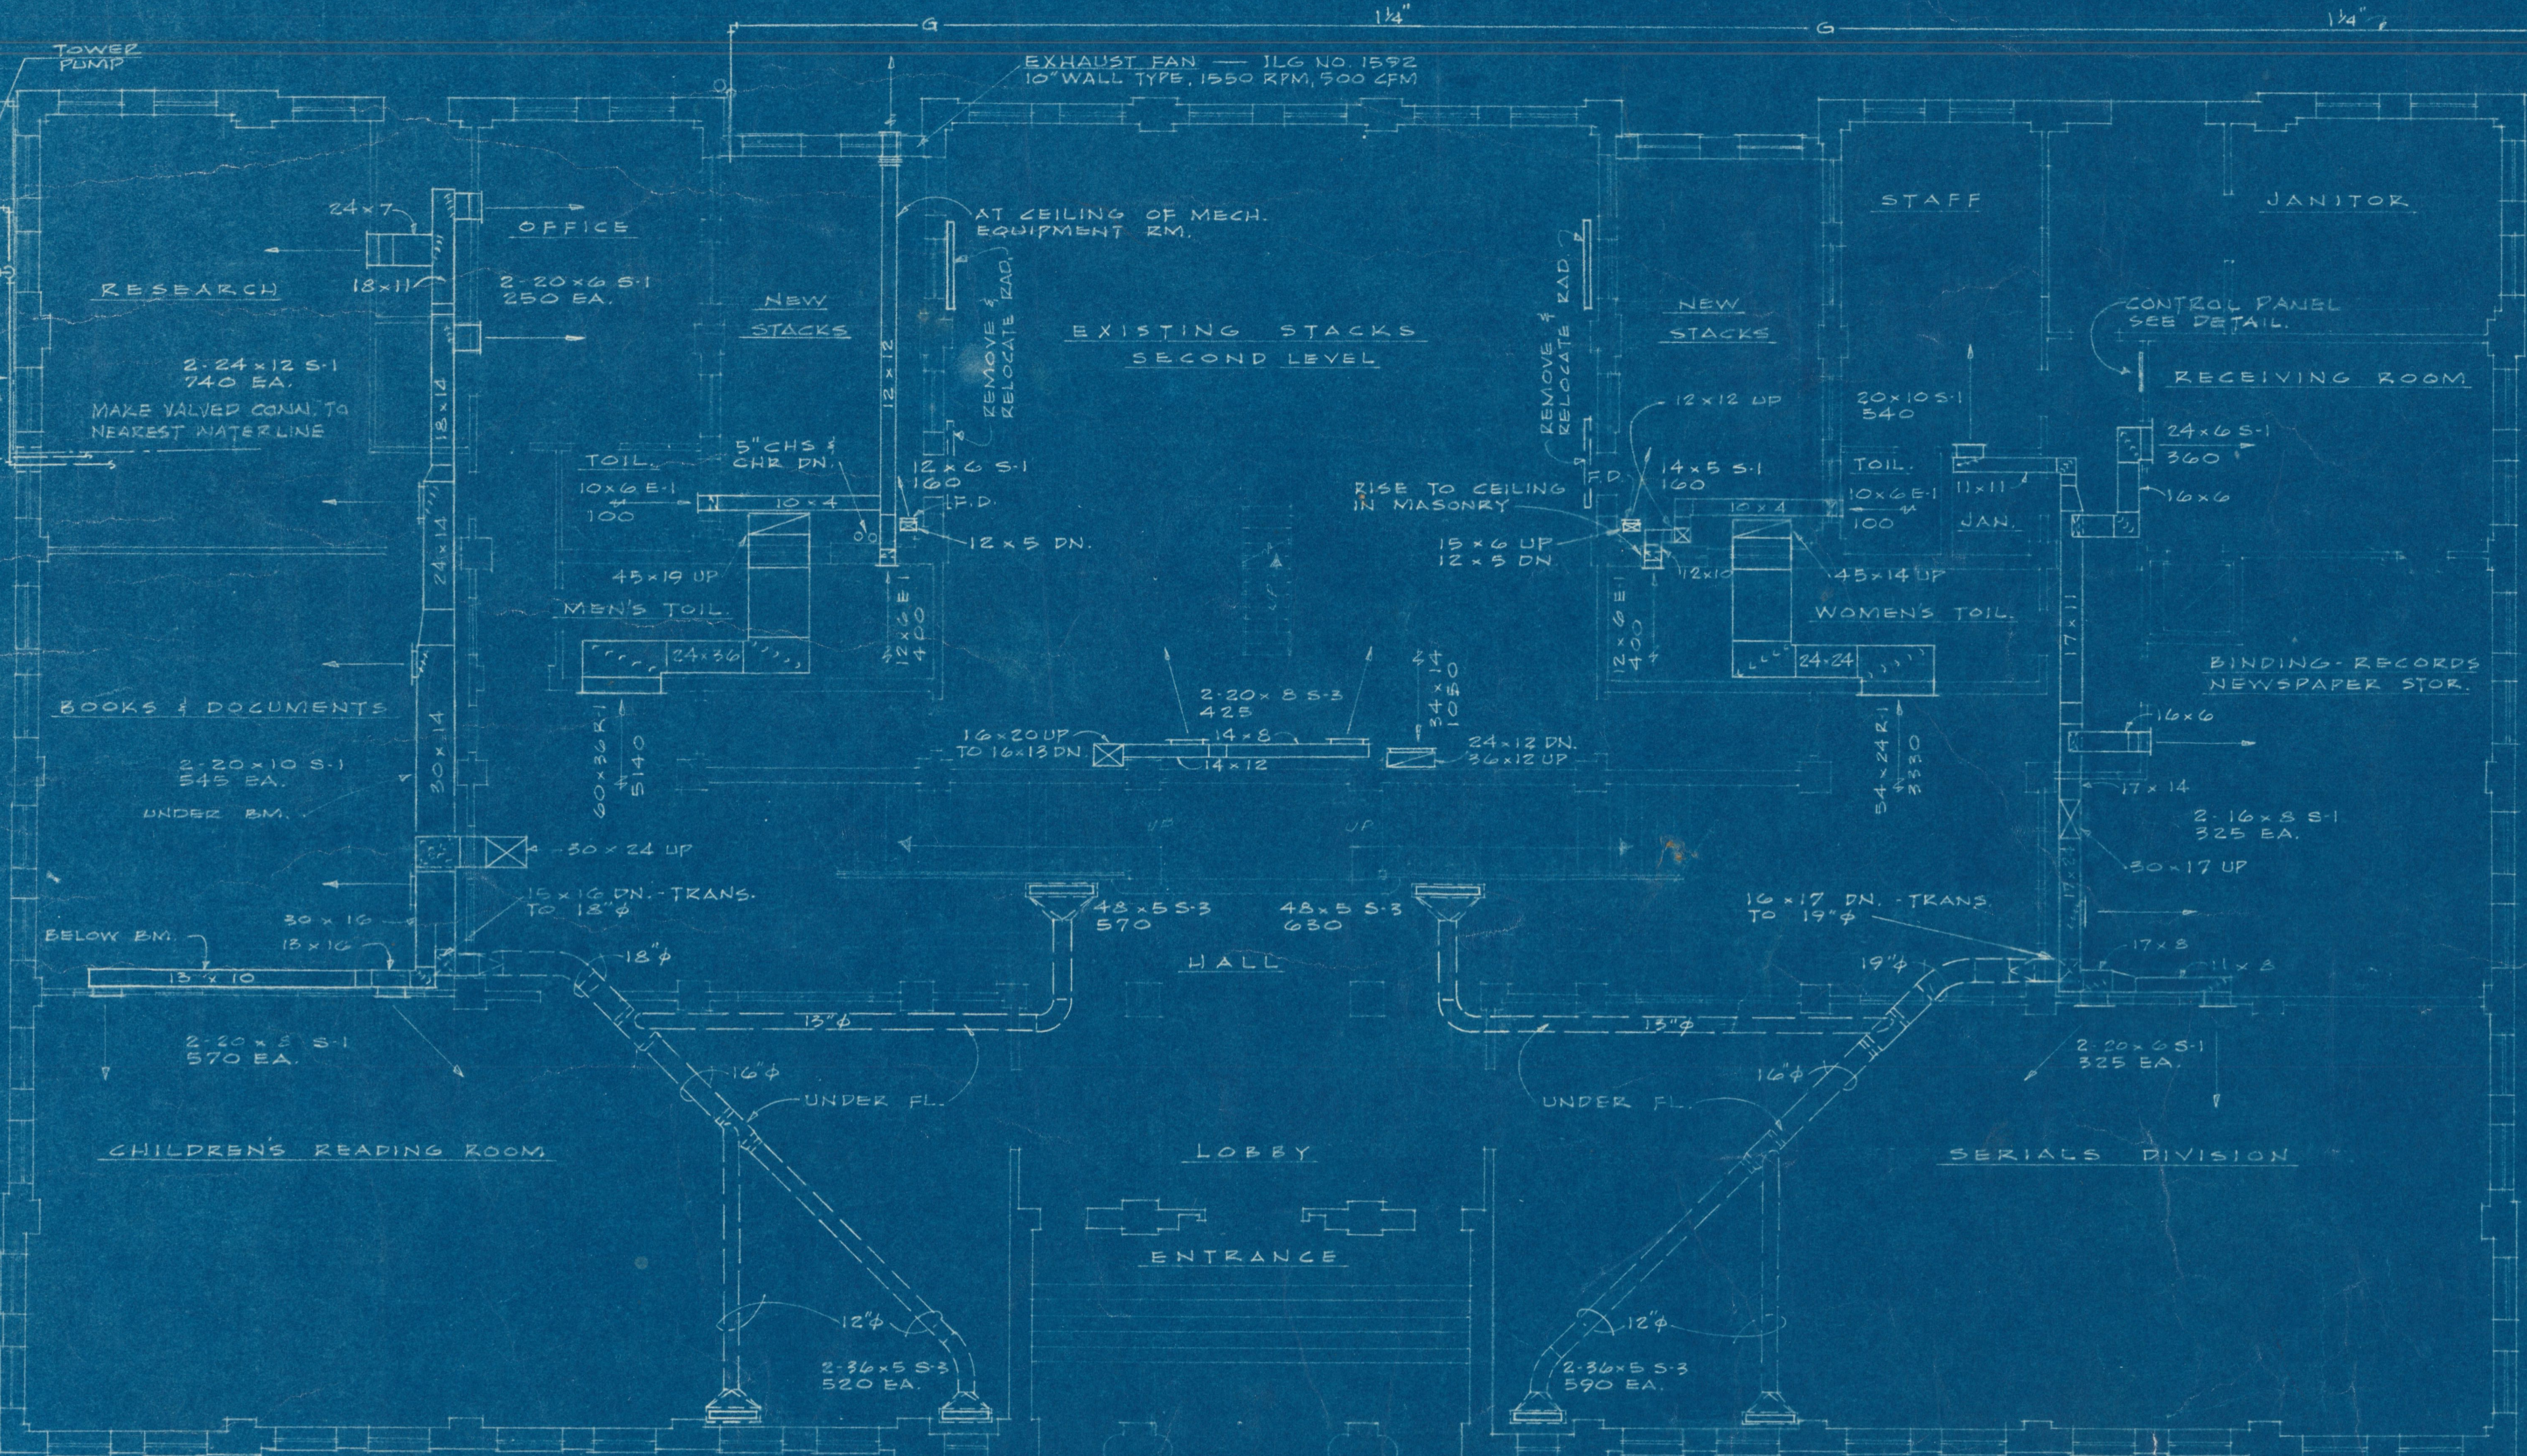


FIRST FLOOR
SCALE: 1/8" = 1'-0"

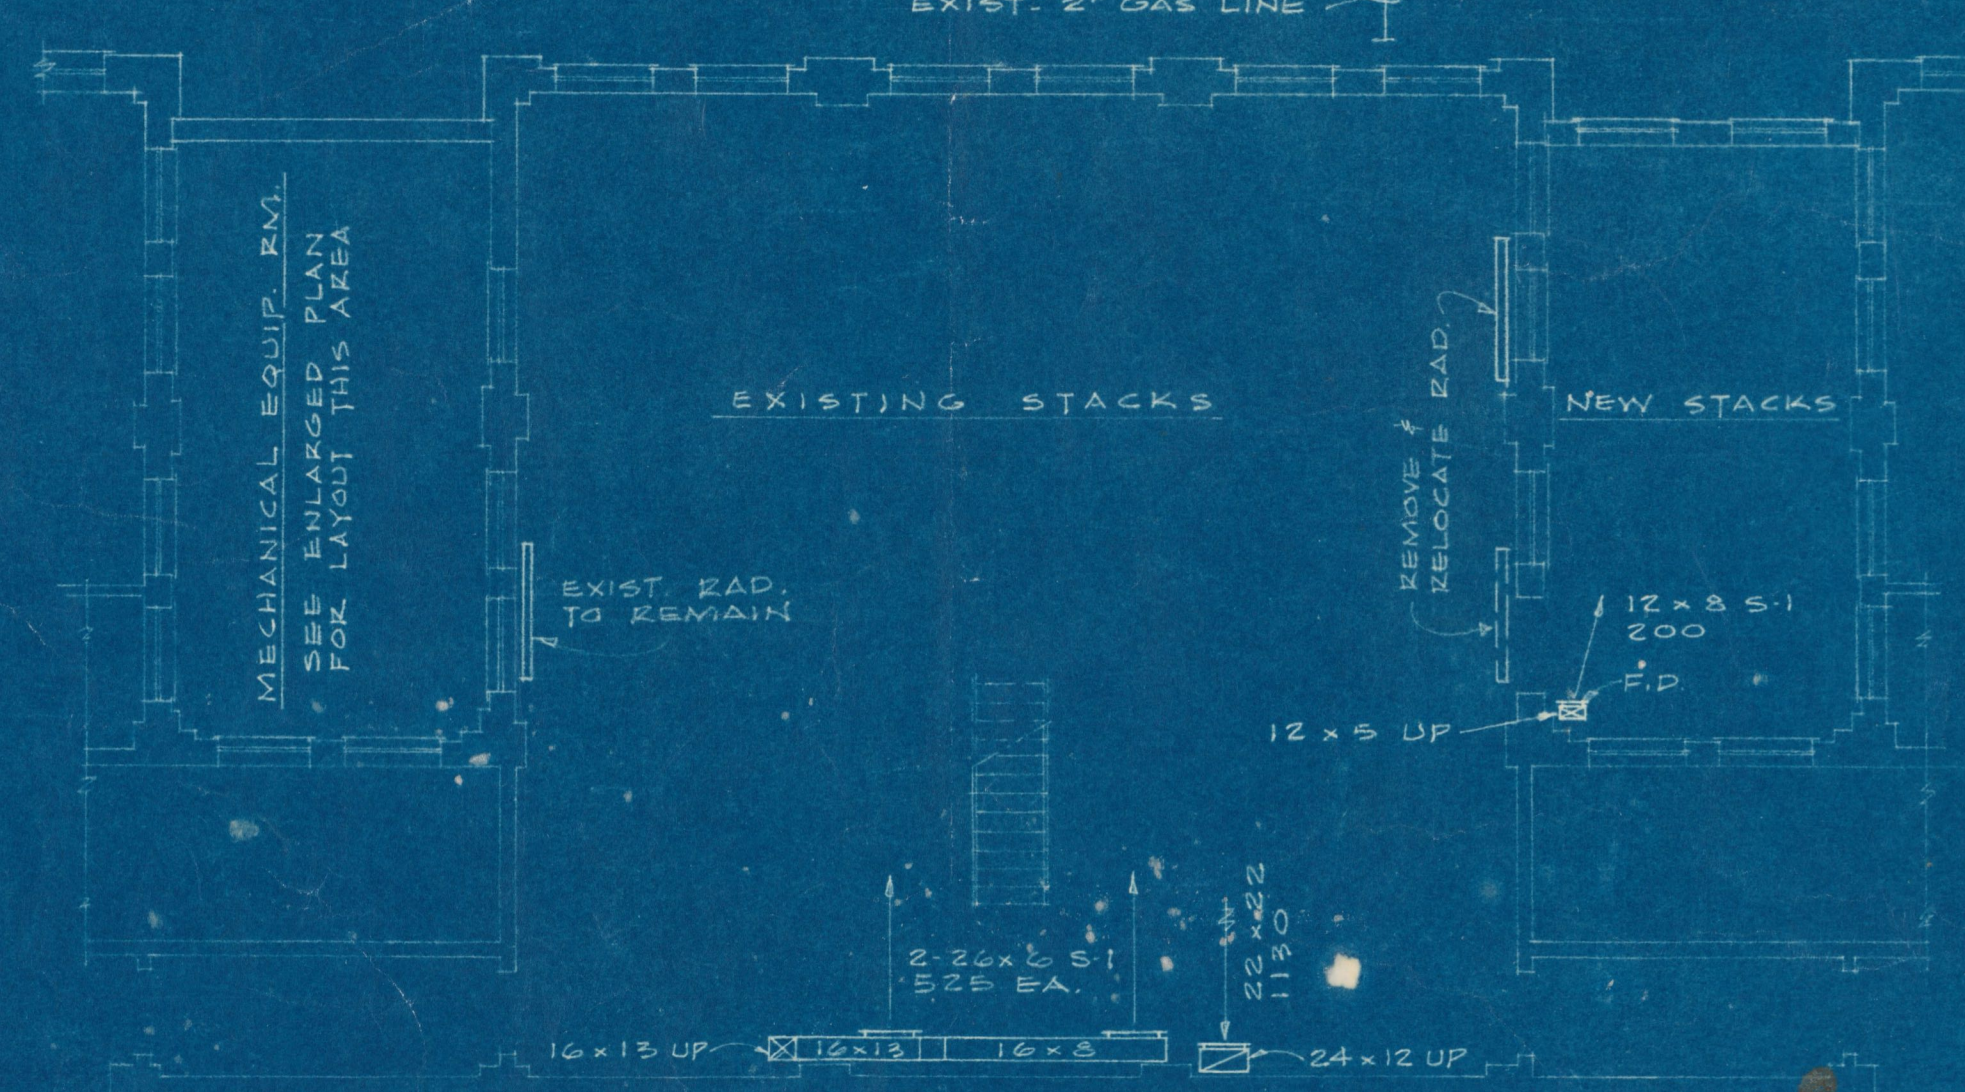


PARTIAL PLAN - STACKS - FIRST LEVEL
FIRST FL.

GRILLES, REGISTERS, & DIFFUSERS

SYMBOL	TYPE	MFG. & MODEL	REMARKS
S-1	SUPPLY SIDEWALL REG.	WATERLOO X25HO	
S-2	SUPPLY CEILING DIFF.	WATERLOO AL250	
S-3	SUPPLY FLOOR REG.	WATERLOO AL250	BORDER STYLE NO. 3
R-1	RETURN SIDEWALL REG.	WATERLOO X25HDO	
E-1	EXHAUST SIDEWALL REG.	WATERLOO 610	1/8" STAMPED ALUM. LATTICE TYPE FACE

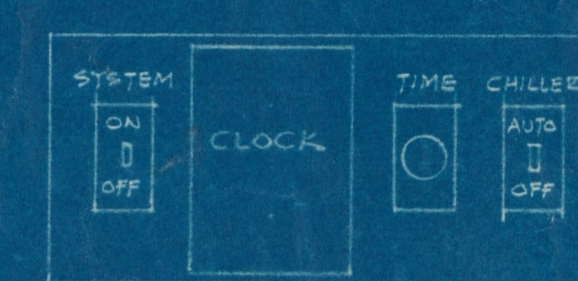

CONTROL PANEL
NO SCALE

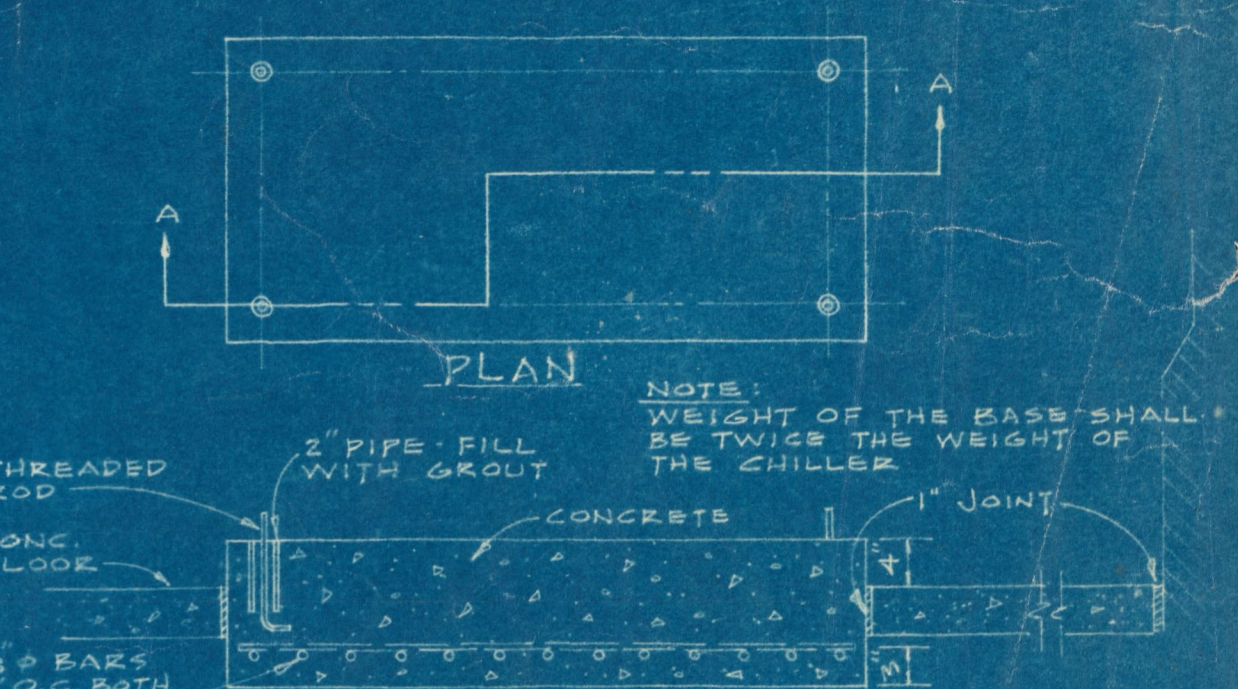

ADDITION & RENOVATION
LIBRARY BUILDING
PROJECT NO. ALA. 4-0361 TUSKEGEE INSTITUTE
TUSKEGEE INSTITUTE, ALABAMA

HEATING, VENTILATING AND AIR CONDITIONING
FIRST & SECOND FLOOR PLANS

MILLER AND ALLAIN, ARCHITECTS
ATLANTA, GEORGIA

DRAWN

TRACED

APPROVED

ISSUE DATE
12-10-65

DRAWING NO.

M-1