



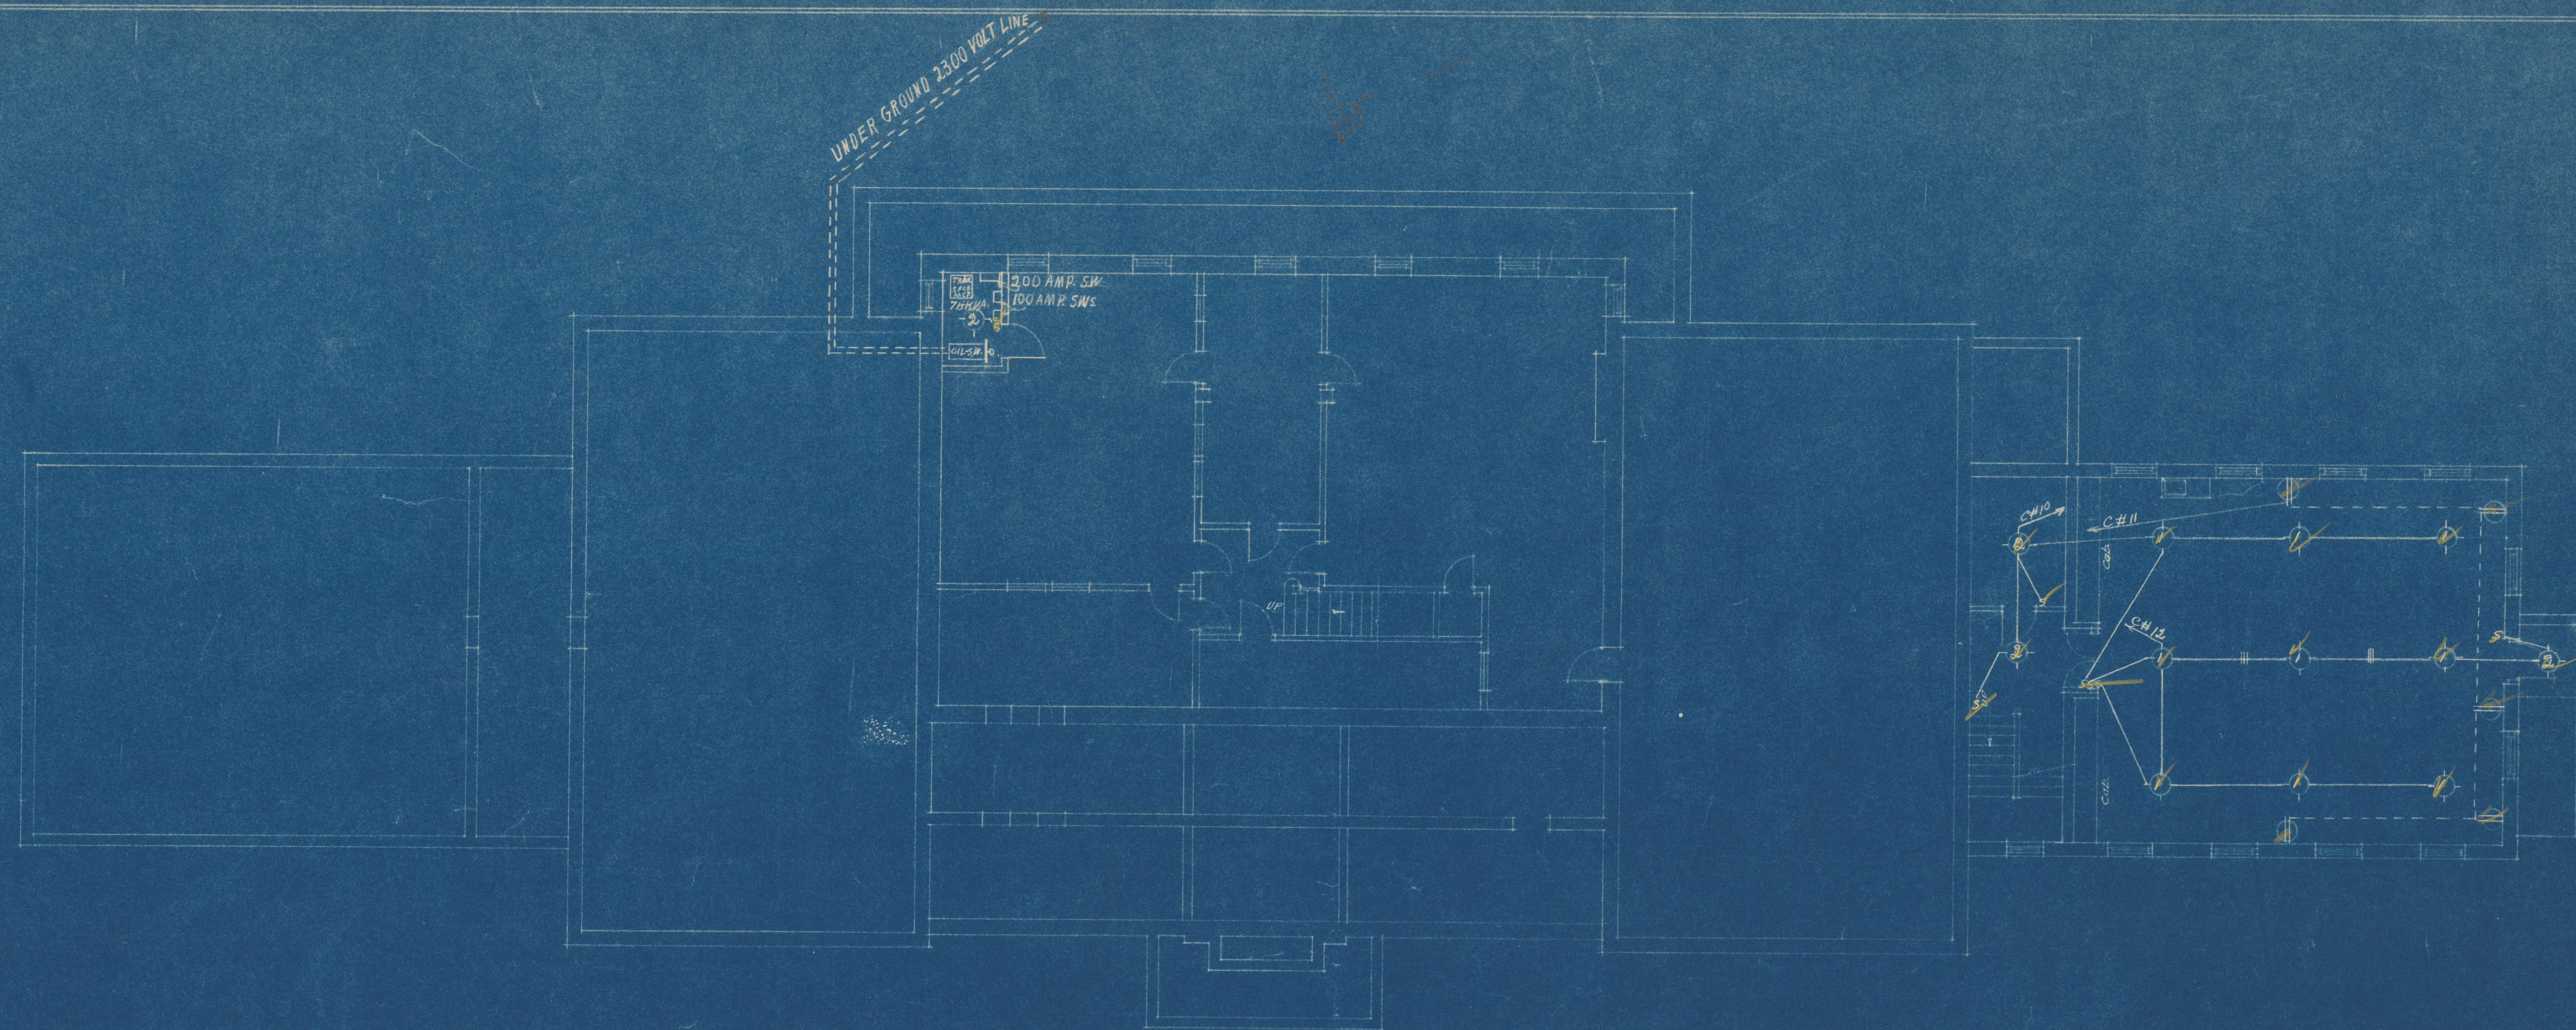

BASEMENT FLOOR PLAN
Scale 1/8" = 1'-0"

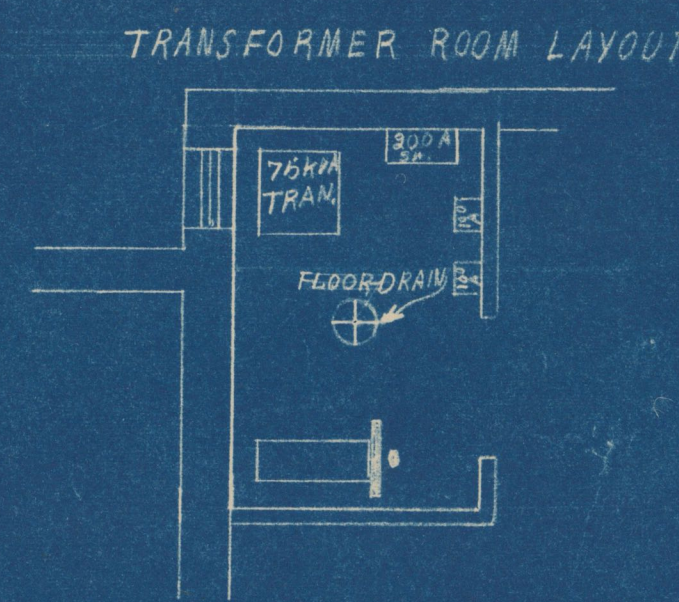

REVISIONS	BY	DATE	PROPOSED ADDITIONS TO HOME ECONOMICS BUILD'G TUSKEGEE INSTITUTE, ALABAMA	
			BASEMENT FLOOR ELECTRICAL PLAN	
			EDWARD G. MILLER : ARCHITECT TUSKEGEE INSTITUTE, ALA.	
			DRAWN BY: G.M.T.	APPROVED BY: <i>E.G.M.</i>
			TRACED BY:	DATE: <i>Oct 29, 1911</i>
			CHECKED BY:	DRAWING NO. E-2