



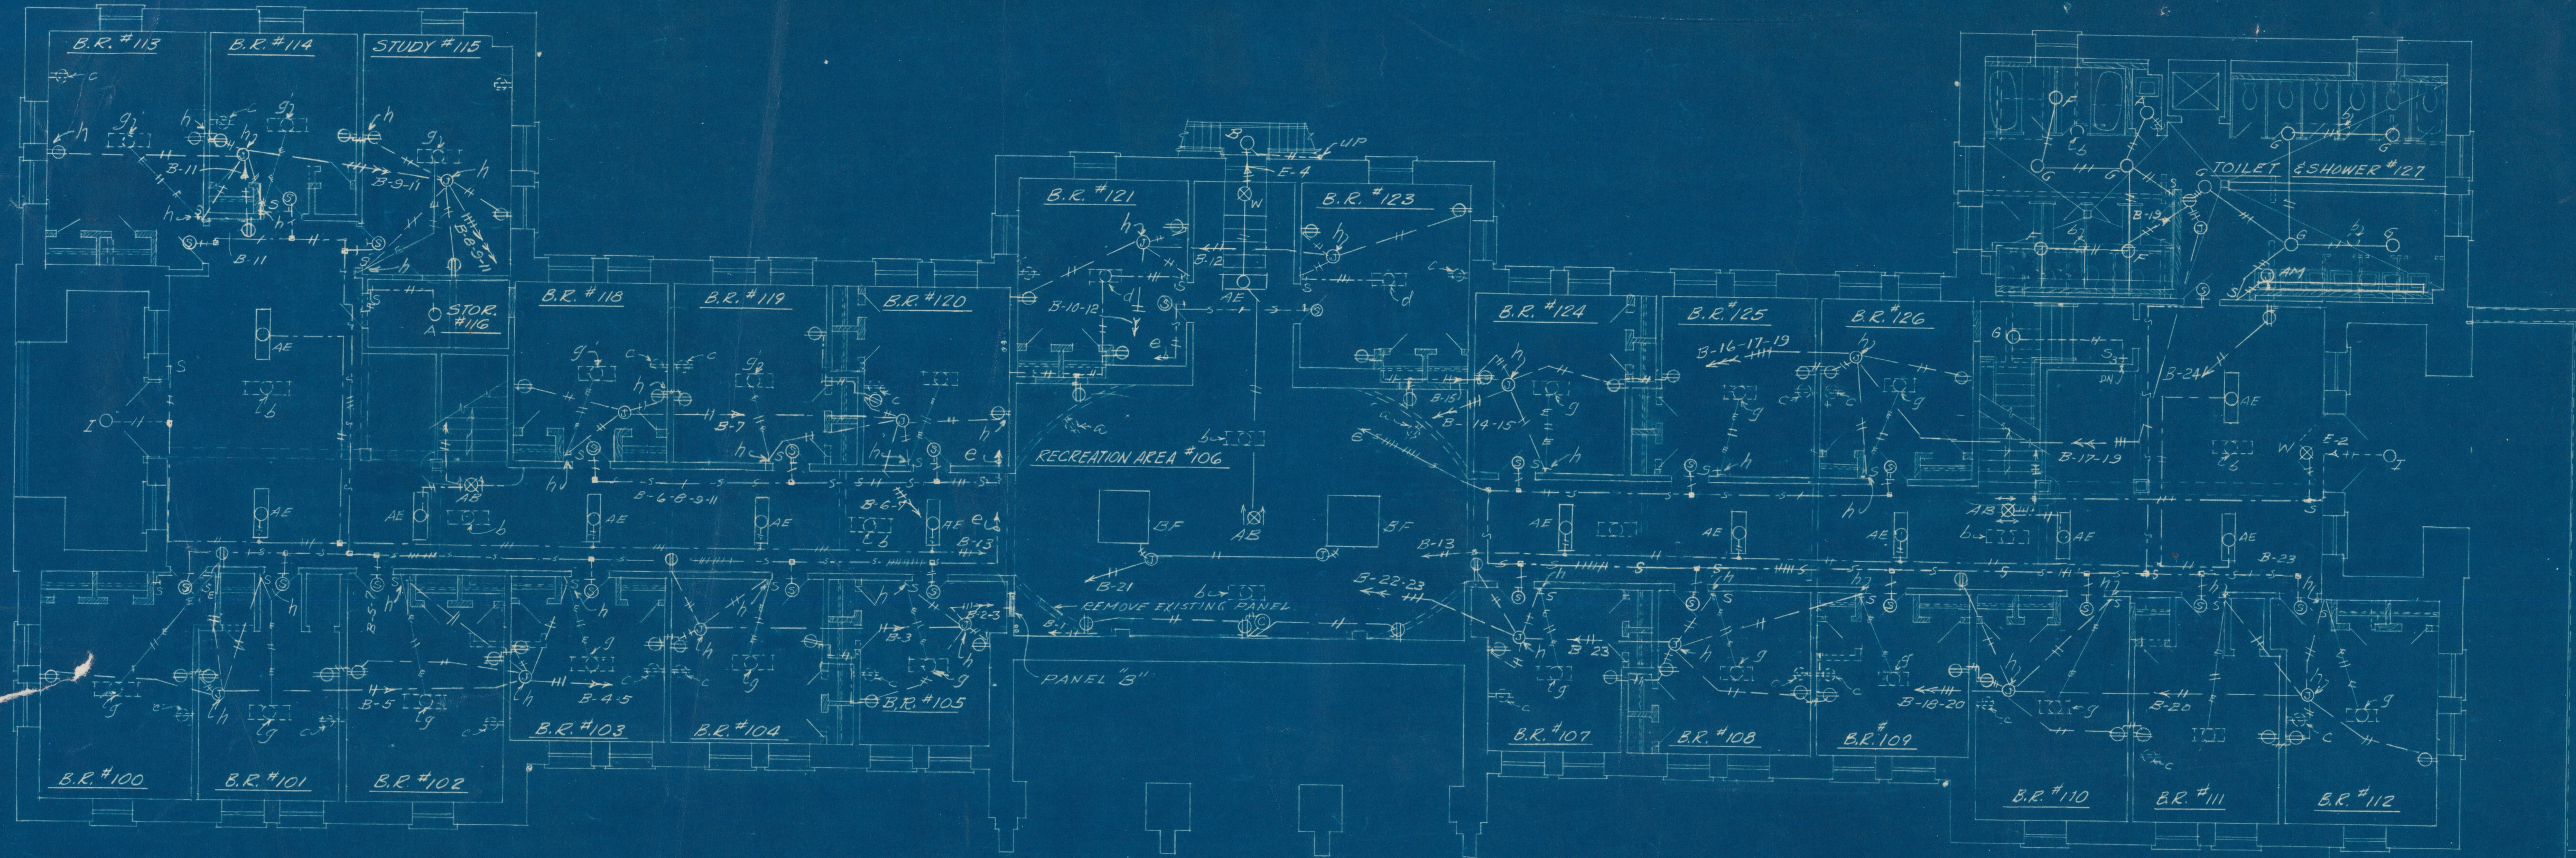

GROUND FLOOR PLAN

SCALE: 1/8" = 1'-0" FLOOR TO FLOOR HEIGHT 13'-0"
44 STUDENTS

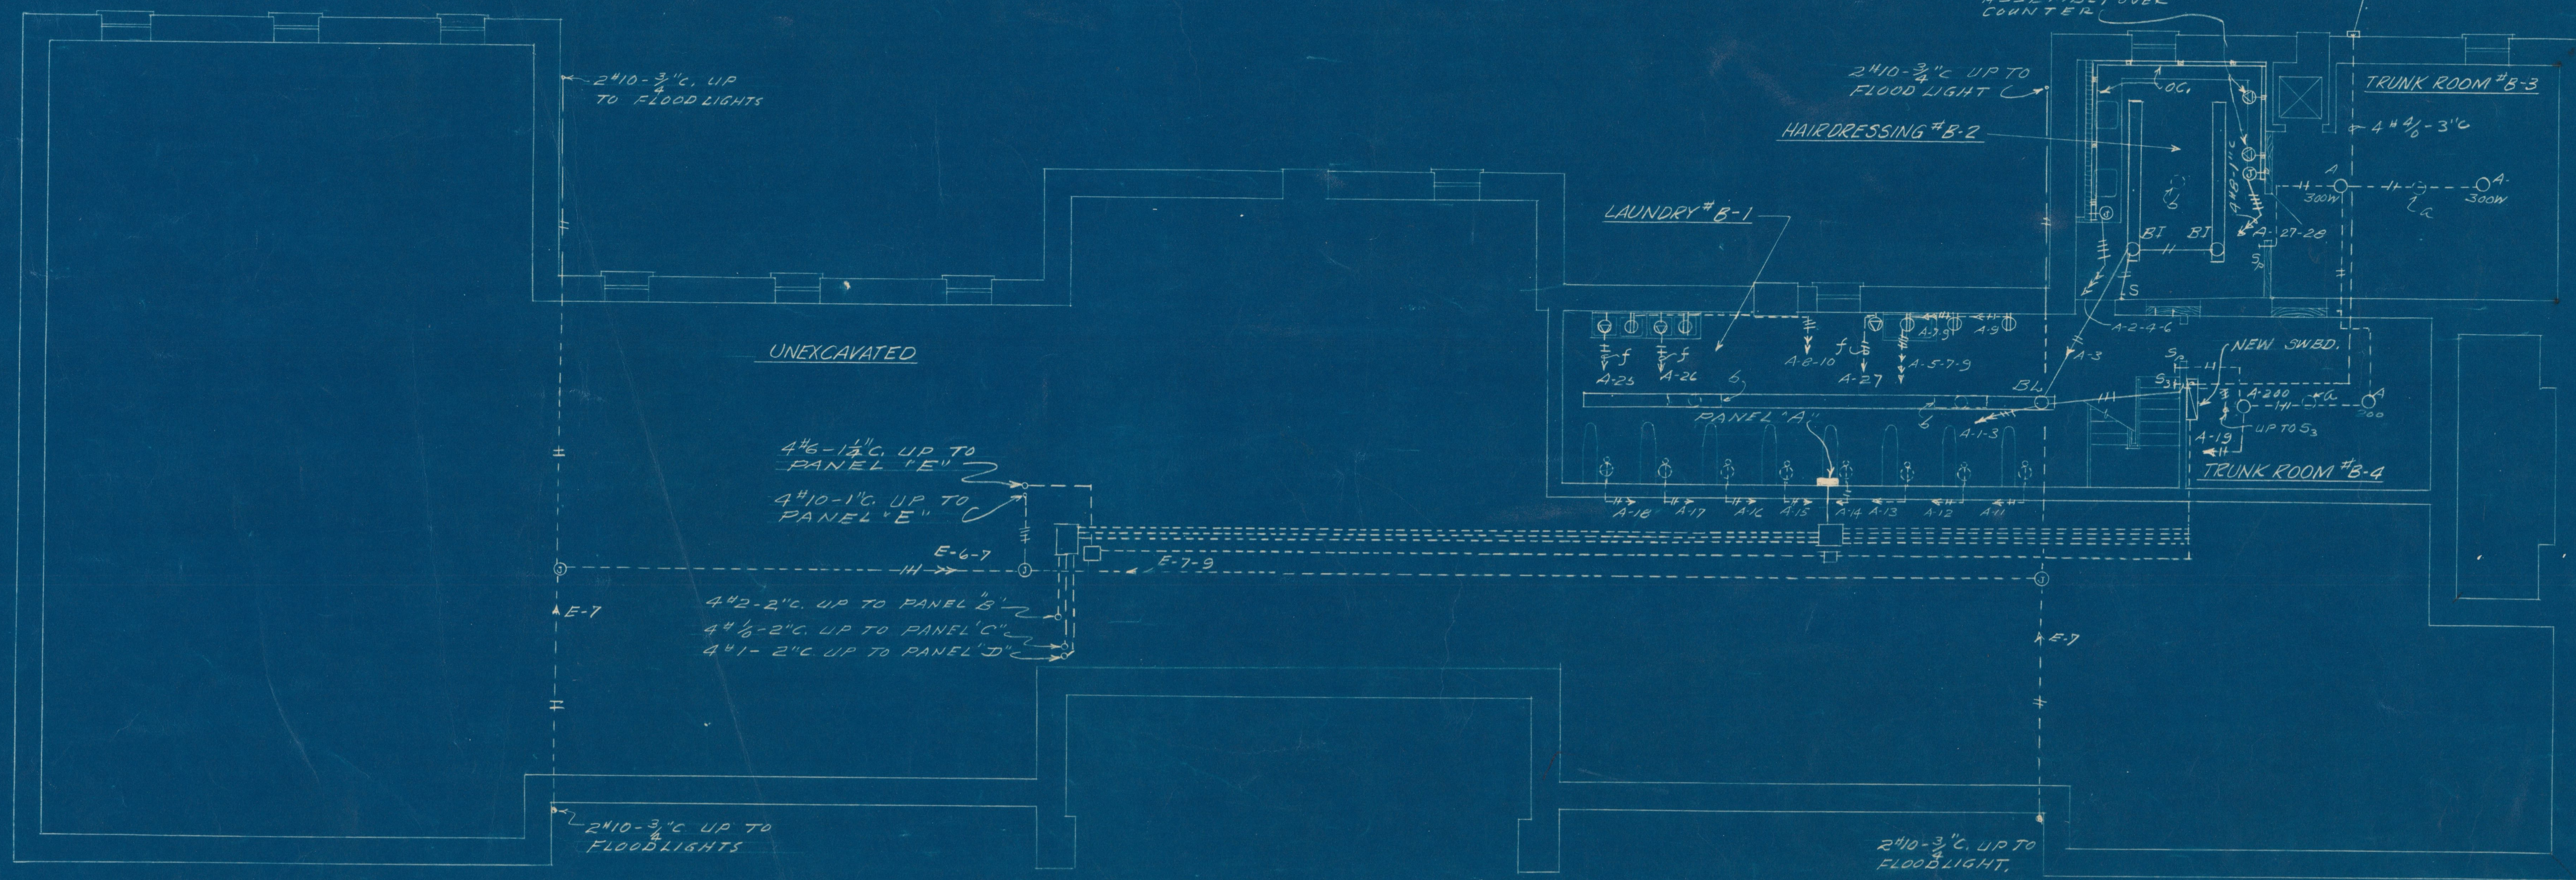


BASEMENT FLOOR PLAN

SCALE: 1/8" = 1'-0" FLOOR TO FLOOR HEIGHT 11'-5"

LEGEND
(FOR THIS SHEET ONLY)

- a- REMOVE OUTLET AND CONNECTIONS.
- b- REMOVE FIXTURE AND OUTLET AND PATCH.
- c- ABANDON EXISTING OUTLET.
- d- REINSTALL EXISTING FIXTURE ON NEW CIRCUIT, ABANDON OLD OUTLET.
- e- TO INTERCOM CONTROL STA. ON 1ST FLOOR.
- f- 5-10-1" C.
- g- EXISTING FIXTURE TO REMAIN PULL IN NEW WIRES.
- h- JUNCTION BOX IN CRAWL SPACE BENEATH FLOOR EXTEND ENT. TO 1" ABOVE FLOOR AT WALLS. INSTALL ADAPTER AND RUN SURFACE METAL RACEWAY UP WALL TO RECEPT OR SW.

2-1/2" 3/4" UNDERGROUND TO POWER CENTER LOCATION OF POWER CENTER TO BE DETERMINED BY OWNER, (AT REAR OF RESIDENCE HALL)

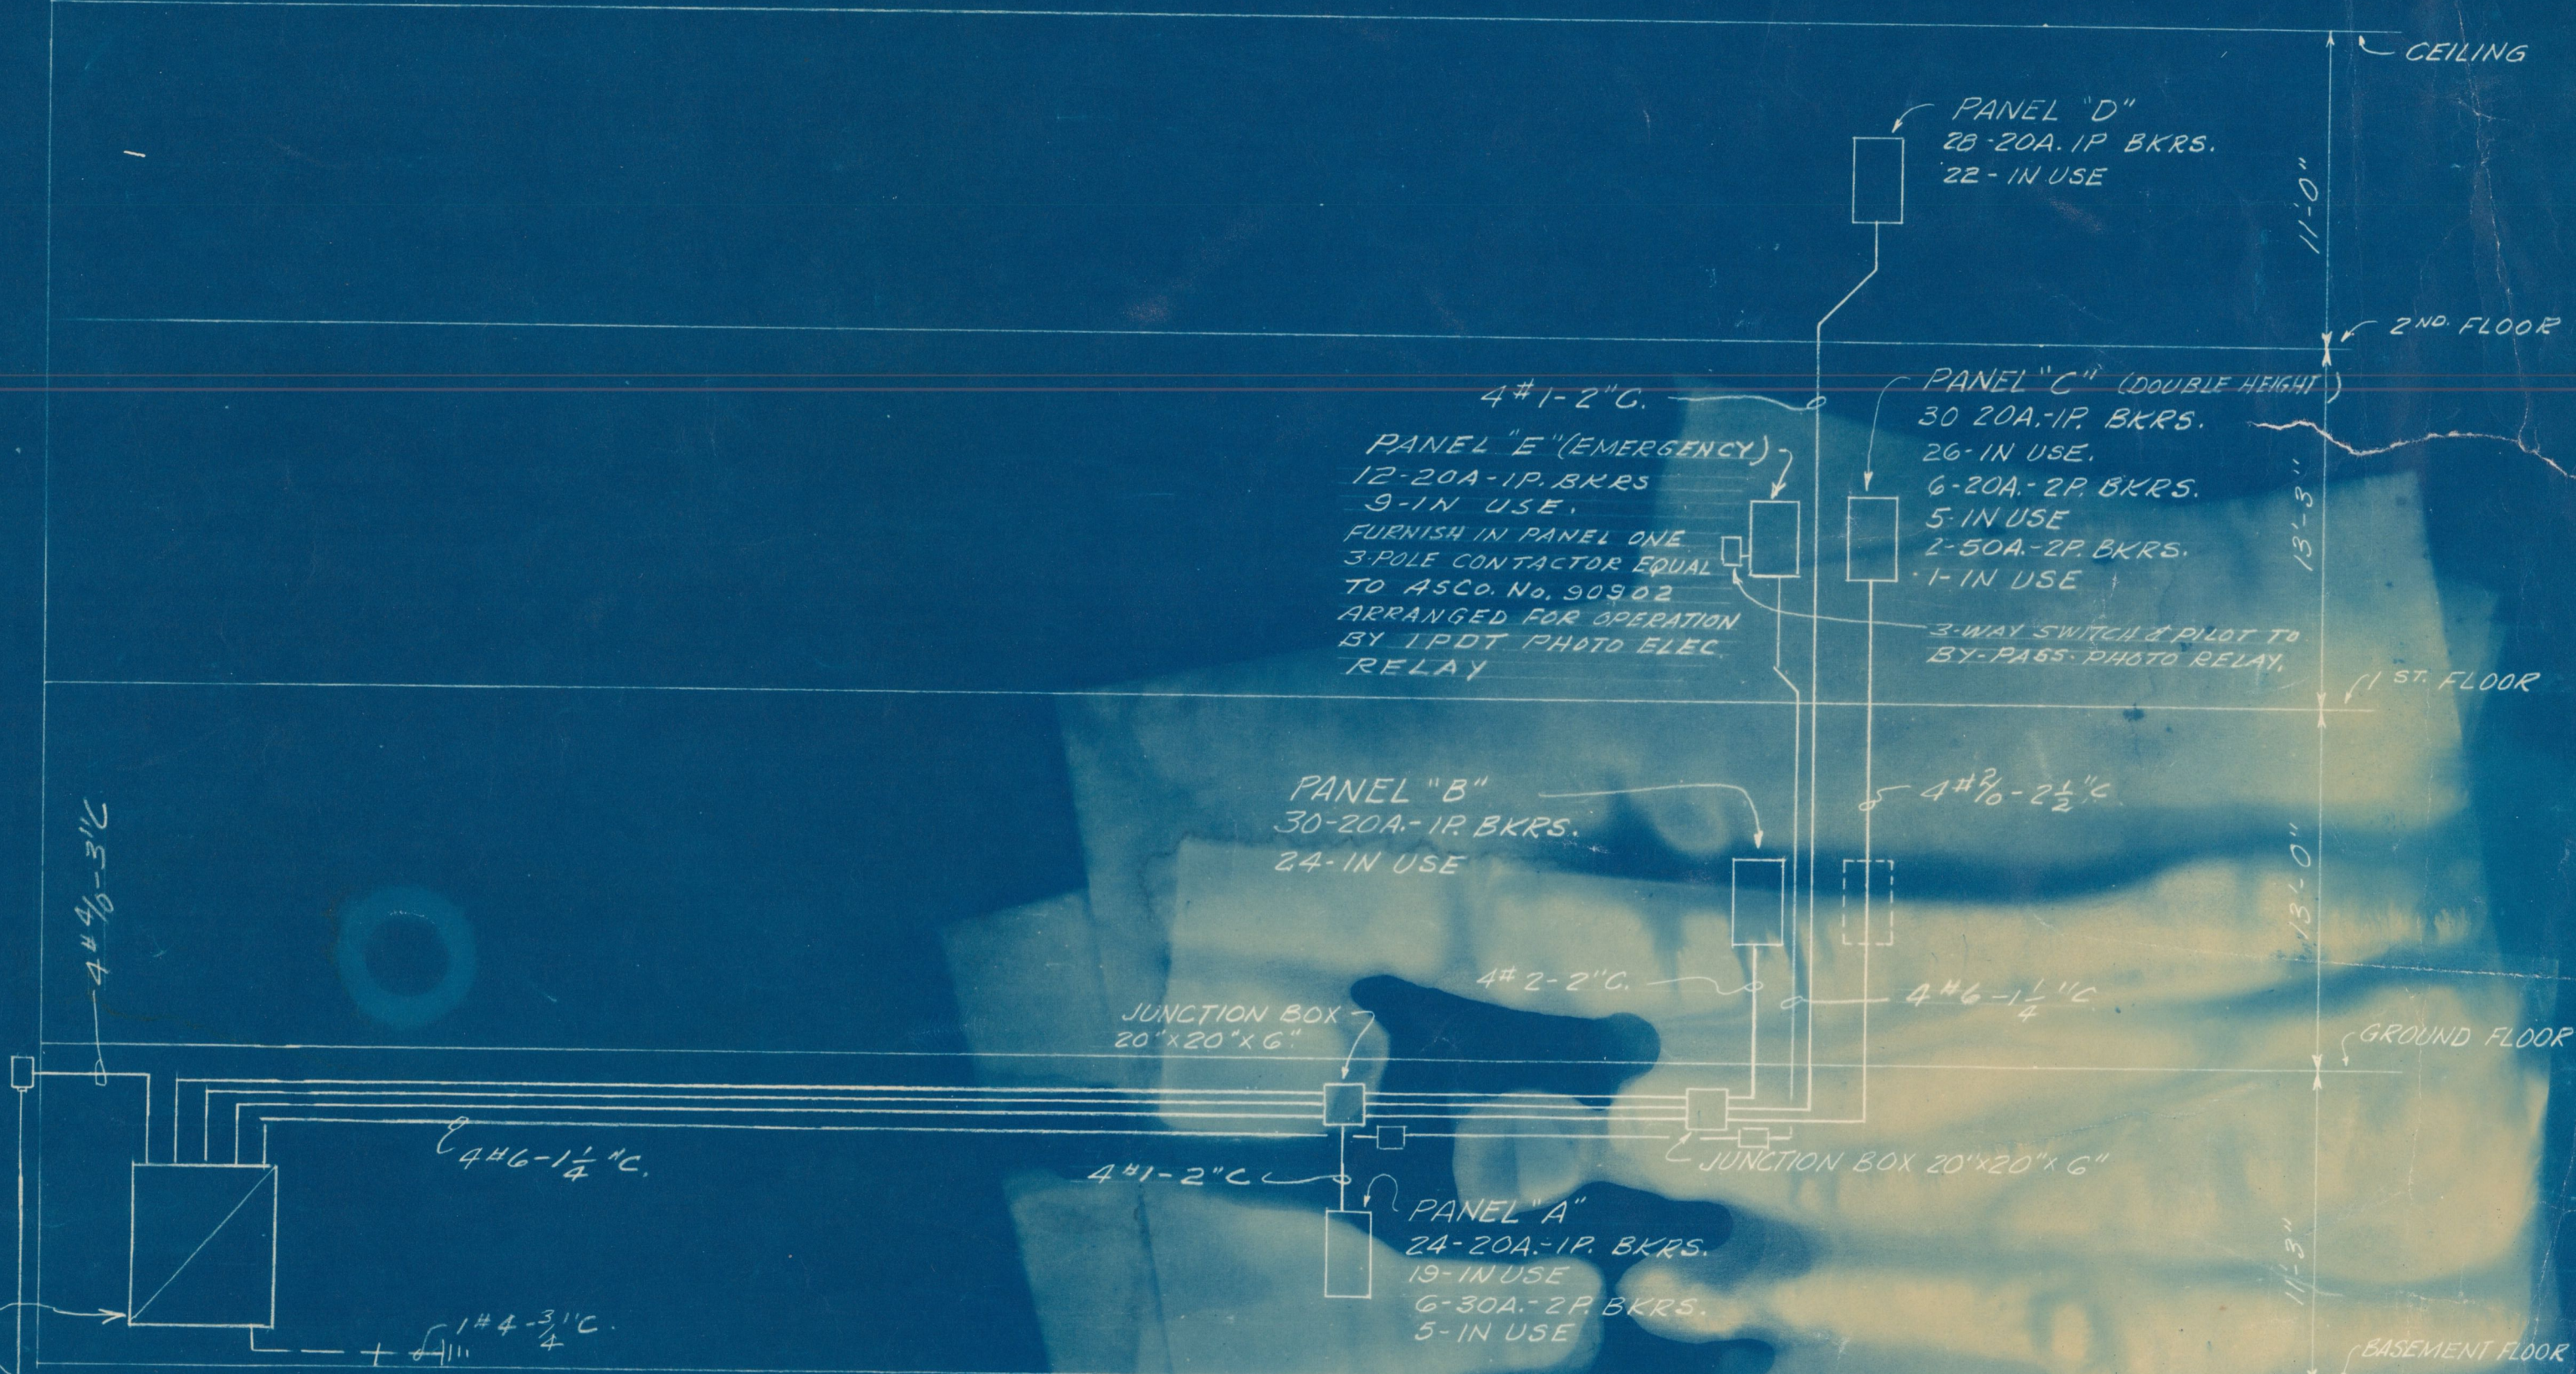

RISER DIAGRAM
NOT TO SCALE

E.K. AUSTIN
REGISTERED ELECTRICAL ENGINEER
ALABAMA LICENSE NO. 2285

VERIFY ALL DIMENSIONS AT THE JOB.
CHECK OUTLET LOCATIONS WITH OTHER PLANS.
OUTLETS LOCATED BEHIND PIPES, RADIATORS,
SHELVES, ETC. ARE TO BE MOVED AS DIRECTED
BY THE ARCHITECT.

GEFFKEN, AUSTIN AND ASSOCIATES
PROFESSIONAL ELECTRICAL ENGINEERS
732 W. PEAUCHIE ST., N. W.
ATLANTA 5, GEORGIA

REVISIONS	FACULTY & STUDENT HOUSING STUDENT UNION TUSKEGEE INSTITUTE			DRAWN E.K.A.
	WHITE HALL BASEMENT & GROUND FLOOR PLANS			TRACED G.C.E.
	MILLER & ALLAIN, ARCHITECTS ATLANTA, GEORGIA			CHECKED J.H.G.
	DRAWING NO. E-10			ISSUE DATE 22 JUN 45